


- NOTES:
- FOR OTHER VOLTAGE CONFIGURATIONS, REFER TO MANUFACTURER'S WIRING INSTRUCTIONS. CONTROL POWER TRANSFORMER SHALL BE PROPERLY SIZED FOR APPLICATION. A MINIMUM OF 2000 VA SHALL BE PROVIDED AND MOUNTED EXTERNALLY. REFER TO FRONT ELEVATION AND BILL OF MATERIALS FOR SPECIFIED LOCATION AND SPECIFICATION OF TRANSFORMER.
  - MOTOR CONTROL WIRING LIMITED TO A MAXIMUM OF:  
20 HP @ 230 VOLTS  
50 HP @ 460 VOLTS

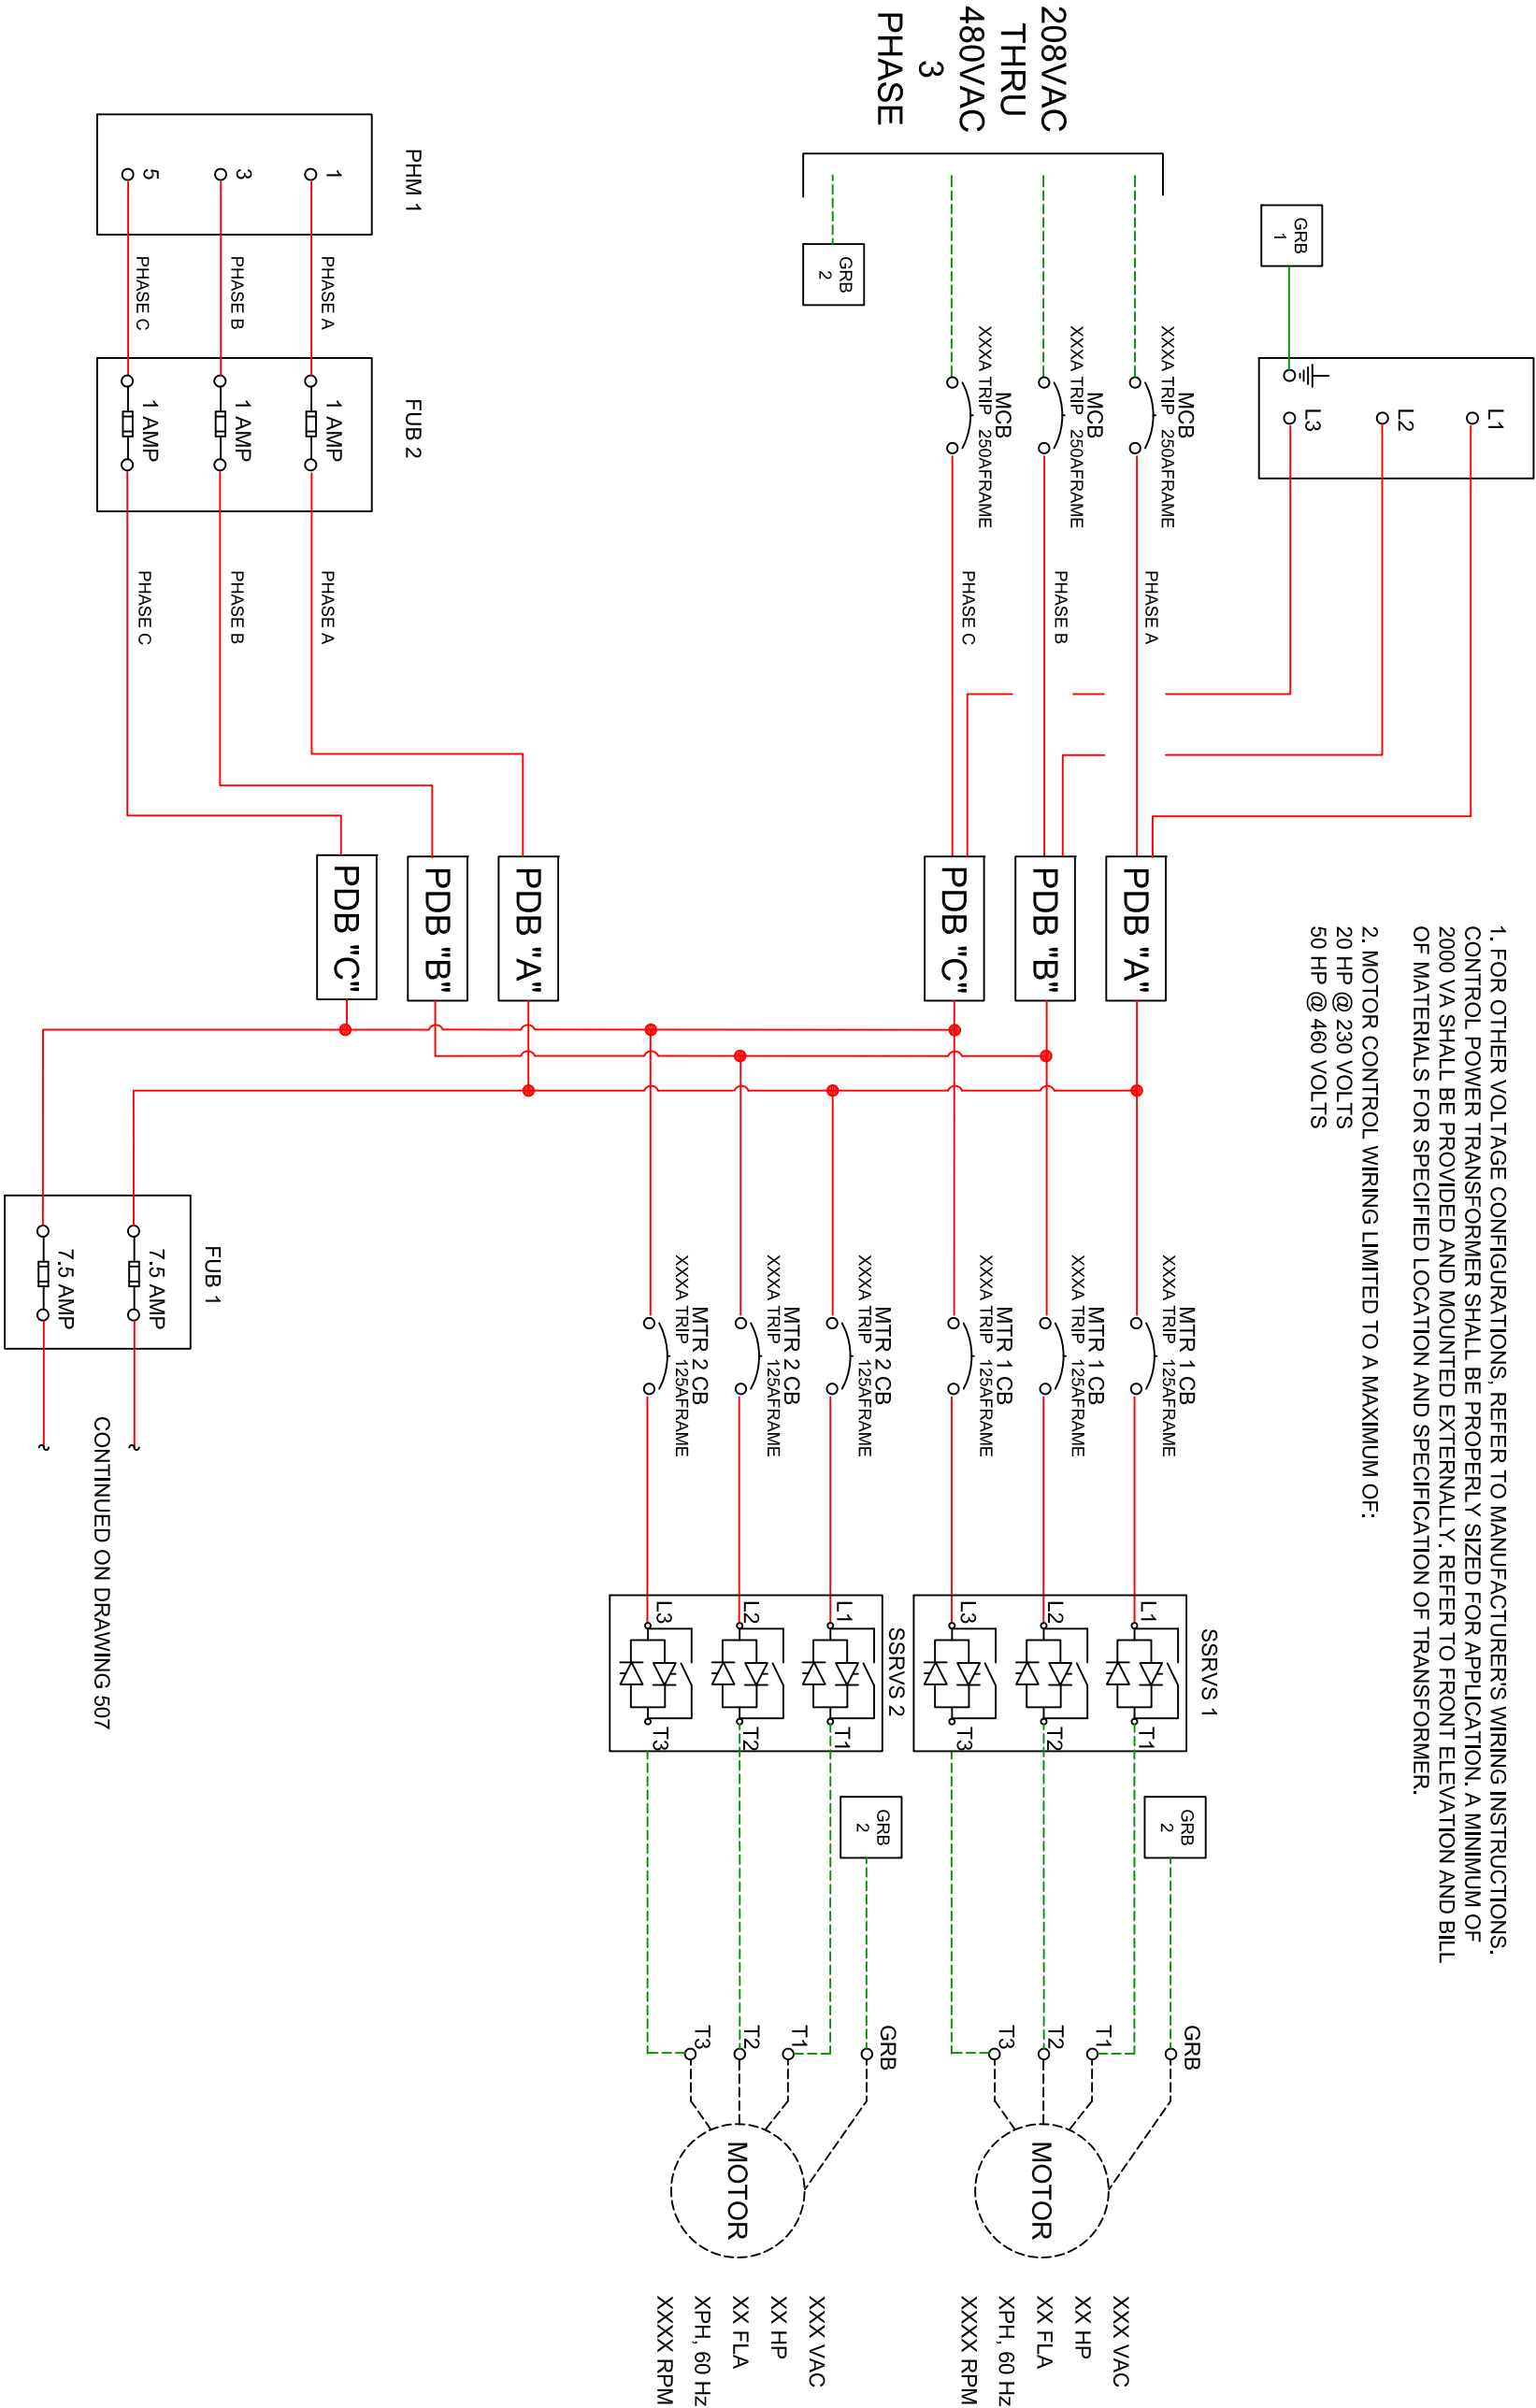

SCALE: N.T.S.	-	REVISIONS AS PER MEETING	10-02-2013	JG	<div>WASTEWATER DIVISION, INDUSTRIAL AUTOMATION GROUP</div> <div>CITY OF ORLANDO, FLORIDA</div>	<div>TITLE: LIFT STATIONS STANDARDS 25 HP TO &lt; 50 HP DUPLEX SSRVS PUMP CONTROLLER FOR STATIONERY GENERATOR ONE LINE WIRING SCHEMATIC</div>	<div>SHEET 506B</div>
DESIGN: JAG / LS							
DRAWN BY: JG							
APPROVED BY: WW	NO	REVISION	DATE	BY			