



- NOTES:
1. FOR OTHER VOLTAGE CONFIGURATIONS, REFER TO MANUFACTURER'S WIRING INSTRUCTIONS. CONTROL POWER TRANSFORMER SHALL BE PROPERLY SIZED FOR APPLICATION. A MINIMUM OF 2000 VA SHALL BE PROVIDED AND MOUNTED EXTERNALLY. REFER TO FRONT ELEVATION AND BILL OF MATERIALS FOR SPECIFIED LOCATION AND SPECIFICATION OF TRANSFORMER.
 2. MOTOR CONTROL WIRING LIMITED TO A MAXIMUM OF:
20 HP @ 230 VOLTS
50 HP @ 460 VOLTS

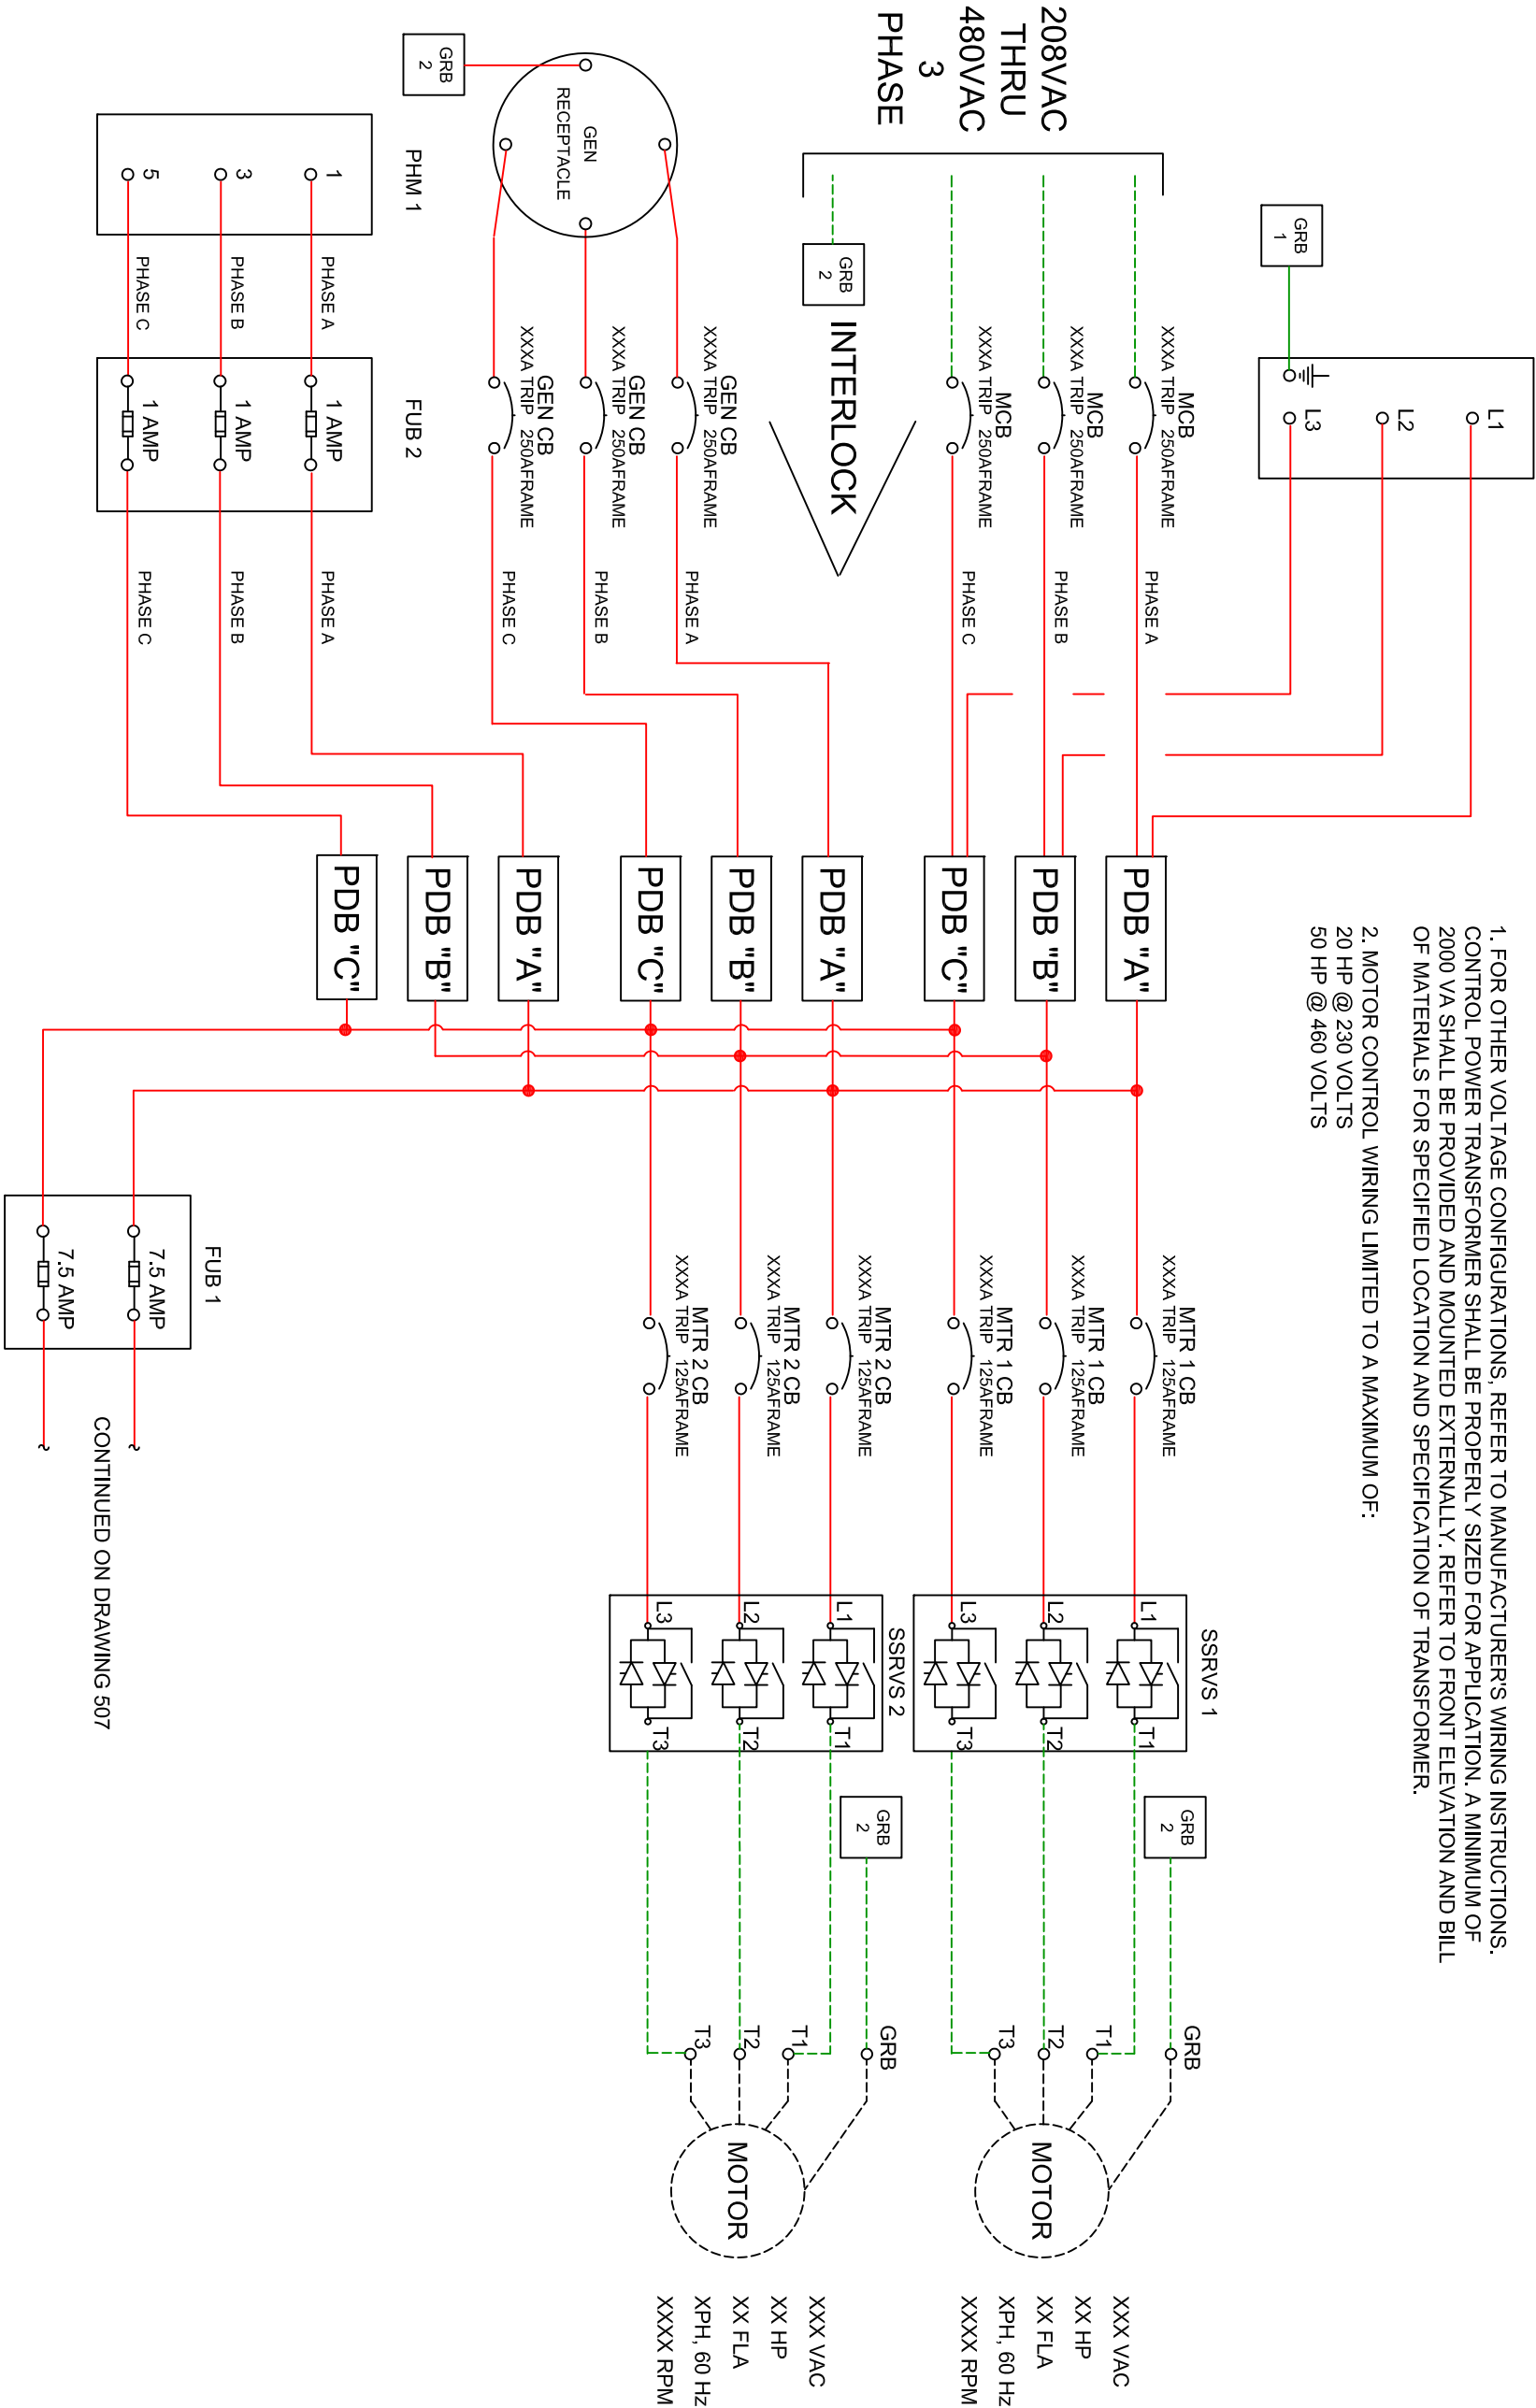

		SCALE: N.T.S.		-		REVISIONS AS PER MEETING		10-02-2013		JG	
		DESIGN: JAG / LS									
		DRAWN BY: JG									
		APPROVED BY: WW		NO		REVISION		DATE		BY	
<div><div><div>WASTEWATER DIVISION, INDUSTRIAL AUTOMATION GROUP</div><div>CITY OF ORLANDO, FLORIDA</div></div></div>											
TITLE: LIFT STATIONS STANDARDS 25 HP TO < 50 HP DUPLEX SSRVS PUMP CONTROLLER FOR PORTABLE GENERATOR ONE LINE WIRING SCHEMATIC											
<div><div>SHEET</div><div>506A</div></div>											