

SURVEYOR'S NOTES

1. THIS SURVEY MEETS THE STANDARDS OF PRACTICE FOR SURVEYING AND MAPPING, CHAPTER 5J-17, FLORIDA ADMINISTRATIVE CODES.
2. THIS SURVEY IS NOT VALID WITHOUT THE SIGNATURE AND THE ORIGINAL RAISED SEAL OF A FLORIDA LICENSED SURVEYOR AND MAPPER OR THE ELECTRONIC SIGNATURE IN COMPLIANCE WITH F.A.C. 5J-17.602(3).
3. THIS SURVEY IS LIMITED TO: THE DOCUMENTATION OF THE PERIMETER OF THE PARCELS OF LAND SHOWN HEREON BY MONUMENTING THE BOUNDARY LINES FOR DESCRIBING SAID PARCELS, THE LOCATION OF SURFACE IMPROVEMENTS WITHIN PROJECT LIMITS AS DESCRIBED IN THE CONTRACT, SPOT ELEVATIONS AND CONTOURS, SPECIMEN TREES, LIMITED TO 10" OR LARGER WITH THE DIAMETER TAKEN AT BREAST HEIGHT (DBH) AS DESCRIBED IN THE CONTRACT, STORM DRAINAGE AND SANITARY SEWER AS-BUILT, SUBSURFACE UTILITIES ASCE QUALITY B - GPR AND SURFACE IMPROVEMENTS.
4. HORIZONTAL DATA SHOWN HEREON AREA BASED ARE BASED ON NORTH AMERICAN DATUM OF 1983, 2011 ADJUSTMENT (NAD83/2011), FLORIDA STATE PLANE EAST REFERENCED TO THE FLORIDA PERMANENT REFERENCE NETWORK (FPRN) STATION ORL1,RELATIVE TO FLORIDA DEPARTMENT OF ENVIRONMENTAL PROTECTION CERTIFIED CORNER RECORD (CCR) NUMBER 96674, BEING A 1/4" IRON ROD IN ASPHALT AND HAVING THE COORDINATES OF 1528656.60', 527309.35'.
5. THE ELEVATIONS SHOWN HEREON ARE BASED UPON CITY OF ORLANDO BENCHMARK 10-122 BEING A 3" ALUMINUM DISK SET IN CURB INLET STAMPED "10-122 CHAMP" AND HAVING A RECORDED ELEVATION OF 101.303'.
6. BEARINGS SHOWN HEREON ARE BASED ON THE SOUTH RIGHT OF WAY LINE OF CHURCH STREET AS BEING N89°25'04"E, ASSUMED.
7. THE SYMBOLS REFLECTED IN THE LEGEND AND ON THIS SURVEY MAY HAVE BEEN ENLARGED FOR CLARITY. THE SYMBOLS HAVE BEEN PLOTTED AT THE CENTER OF THE FIELD LOCATION AND MAY NOT REPRESENT THE ACTUAL SHAPE OR SIZE OF THE FEATURE.
8. THE INFORMATION DEPICTED ON THIS SURVEY REPRESENTS THE RESULTS OF A FIELD SURVEY ON THE DATE INDICATED AND CAN ONLY BE CONSIDERED AS A REPRESENTATION OF THE GENERAL CONDITIONS EXISTING AT THAT TIME.
9. THE SURVEYOR DID NOT INSPECT THE PROPERTY SHOWN HEREON FOR ENVIRONMENTAL HAZARDS. ONLY ADD IF REQUESTED BY CLIENT.
10. FENCES AND WALL DIMENSIONS ARE APPROXIMATE. THE SURVEYOR DID NOT DETERMINE OWNERSHIP OF WALLS AND FENCES.
11. THIS FIRM IDENTIFIED VARIOUS TYPES OF TREES LOCATED ON THIS SITE BASED ON COMMON KNOWLEDGE OF TREE SPECIES. A QUALIFIED LANDSCAPE ARCHITECT SHOULD BE EMPLOYED FOR POSITIVE IDENTIFICATION OF TREE SPECIES. TREE DIAMETERS ARE APPROXIMATE AND WERE MEASURED AT BREAST HEIGHT. ONLY TREES 3 CALIPER INCHES OR LARGER WERE LOCATED AND SHOWN ON THE SURVEY. HEDGES AND GROUND COVER WERE NOT LOCATED AND ARE NOT SHOWN. EXOTIC TREES SUCH AS MELALEUCA, BRAZILIAN PEPPER AND AUSTRALIAN PINE WERE NOT LOCATED OR SHOWN HEREON.
12. ORNAMENTAL PLANTS, HEDGES, SPRINKLER HEADS WERE NOT LOCATED UNLESS SHOWN HEREON.
13. A SUNSHINE 811 "DESIGN" TICKETS #079503443, 079503492, 079503466, 079503282 WERE OBTAINED TO DETERMINE THE UTILITY PROVIDERS WITHIN THE PROJECT LIMITS. THE PROJECT WAS SCANNED FOR UNDERGROUND UTILITIES USING ELECTRONIC DETECTION DEVICES AND GROUND PENETRATING RADAR (GPR). ANY UTILITIES FOUND WITHIN THE PROJECT LIMITS WERE SURFACE PAINTED AND FLAGGED WITH THE APPROPRIATE COLOR AS RECOGNIZED BY THE NATIONAL UTILITY LOCATING CONTRACTORS ASSOCIATION (NULCA). ANY UTILITIES MARKED BY ANOTHER FIRM WILL BE VERIFIED BY AN L&S DIVERSIFIED UTILITY LOCATOR.
14. THIS SITE COULD HAVE UNDERGROUND INSTALLATIONS THAT ARE NOT SHOWN. BEFORE DESIGN, CONSTRUCTION EXCAVATIONS, CONTACT SUNSHINE811.COM AND THE APPROPRIATE UTILITY COMPANIES FOR FIELD VERIFICATION OF UTILITIES.
15. IT SHOULD BE UNDERSTOOD BY THE CLIENT THAT SOME UNDERGROUND UTILITIES MAY NOT BE MADE OF A CONDUCTIVE MATERIAL OR MAY NOT RETURN A GROUND PENETRATING RADAR (GPR) ECHO AND THEREFORE CANNOT BE DESIGNATED WITH ELECTRONIC PROSPECTING EQUIPMENT OR GPR IF PERFORMED.
16. L & S DIVERSIFIED, LLC DID NOT SEARCH THE PUBLIC RECORDS FOR OWNERSHIP, RIGHTS-OF-WAY, EASEMENTS OR OTHER MATTERS AFFECTING THE PROPERTY BEING SURVEYED. THERE MAY BE ADDITIONAL RESTRICTIONS NOT SHOWN ON THIS SURVEY THAT MAY BE FOUND IN THE PUBLIC RECORDS.
17. THE INFORMATION CONTAINED IN THIS DOCUMENT WAS PREPARED BY L & S DIVERSIFIED, LLC (L&S). L&S HAS TAKEN ALL REASONABLE STEPS TO ENSURE THE ACCURACY OF THIS DOCUMENT. WE CANNOT GUARANTEE THAT ALTERATIONS AND/OR MODIFICATIONS WILL NOT BE MADE BY OTHERS AFTER IT LEAVES OUR POSSESSION. THIS DOCUMENT MUST BE COMPARED TO THE ORIGINAL HARD COPY (WHICH BEARS THE RAISED SURVEYORS CERTIFICATION SEAL IF APPLICABLE) TO ENSURE THE ACCURACY OF THE INFORMATION CONTAINED HEREON AND TO FURTHER ENSURE THAT ALTERATIONS AND/OR MODIFICATIONS HAVE NOT BEEN MADE. L&S MAKES NO WARRANTIES, EXPRESS OR IMPLIED, CONCERNING THE ACCURACY OF THE INFORMATION CONTAINED IN THIS OR ANY DOCUMENT TRANSMITTED OR REVIEWED BY COMPUTER OR OTHER ELECTRONIC MEANS. CONTACT L&S DIRECTLY FOR VERIFICATION OF ACCURACY.
18. THIS SURVEY MAP IS INTENDED TO BE DISPLAYED AT A SCALE OF 1" = 20' OR SMALLER.
19. THIS SURVEY CANNOT BE RELIED UPON BY PERSONS OR ENTITIES OTHER THAN THE PERSONS OR ENTITIES CERTIFIED TO HEREON.
20. ADDITIONS OR DELETIONS TO THIS SURVEY MAP BY OTHER THAN THE SIGNING PARTY OR PARTIES ARE PROHIBITED WITHOUT WRITTEN CONSENT OF THE SIGNING PARTY OR PARTIES.
21. THE DESCRIPTION OF THE SUBJECT PROPERTY FORMS A MATHEMATICALLY CLOSED FIGURE WITH NO GORES, GAPS, OVERLAPS OR HIATUS.
22. THE SURVEYOR FOUND NO EVIDENCE OF A CEMETERY OR BURIAL GROUND ON THIS PROPERTY IN THE COURSE OF CONDUCTING FIELD WORK.

SYMBOL AND ABBREVIATION LEGEND:

	ELECTRICAL CABINET		SET TRAVERSE POINT OR BENCHMARK	N	NORTH/NORTHING
	CONCRETE LIGHT POLE		TELECOMMUNICATION CABINET	N/D	NAIL AND DISK
	CONCRETE POWER POLE		TELECOMMUNICATION RISER	ORB	OFFICIAL RECORDS BOOK
	GUY WIRE		TELECOMMUNICATION VAULT	PB	PLAT BOOK
	LANDSCAPE LIGHT		PEDESTRIAN CROSS POLE	PC(S)	PAGE(S)
	ELECTRICAL MANHOLE		SIGNAL MAST ARM	PL	PROPERTY LINE
	METAL LIGHT POLE		TRAFFIC ELECTRIC VAULT	PSM	PROFESSIONAL SURVEYOR AND MAPPER
	ELECTRICAL METER		TREE CYPRESS	PVC	POLYVINYL CHLORIDE PIPE
	ELECTRICAL PANEL		TREE LIVE OAK	R	RADIUS
	ELECTRICAL RISER		TREE MAGNOLIA	RCP	REINFORCED CONCRETE PIPE
	TRANSFORMER		TREE PALM	RLS	REGISTERED LICENSED SURVEYOR
	ELECTRICAL VAULT		TREE PINE	R/W	RIGHT OF WAY
	WOODEN LIGHT POLE		BACKFLOW PREVENTER	S	SOUTH
	WOODEN POWER POLE		FIRE DEPARTMENT CONNECTION	TH	TEST HOLE
	FIBER OPTIC MARKER		FIRE HYDRANT	VCP	VITRIFIED CLAY PIPE
	FIBER OPTIC VAULT		HOSE BIBB	W	WEST
	IRRIGATION VALVE		WATER METER	--- 25 ---	CONTOUR
	ANTENNA		WATER POST INDICATOR VALVE	--- 24.1 ---	SPOT ELEVATION
	BOLLARD		WATER VALVE	--- 87Y ---	BURIED CABLE TV
	CLEANOUT		BENCHMARK	--- 8C ---	BURIED ELECTRICAL
	MONITORING WELL		CENTER LINE	--- 8FO ---	BURIED FIBER OPTIC
	MULTI STAND SIGN		CHORD DISTANCE	--- 8G ---	BURIED GAS
	SINGLE STAND SIGN		CHORD BEARING	--- 8S ---	BURIED SANITARY SEWER
	UNKNOWN VAULT		CHAIN LINK FENCE	--- 8T ---	BURIED TELECOMMUNICATION
	NATURAL GAS MARKER		CONCRETE	--- 8TE ---	BURIED TRAFFIC ELECTRICAL
	NATURAL GAS VALVE		CONCRETE MONUMENT	--- 8U ---	BURIED UNKNOWN
	NATURAL GAS VENT		CORRUGATED METAL PIPE	--- 8W ---	BURIED WATER
	RECLAIMED WATER VALVE		CORRUGATED PLASTIC PIPE	---	CENTERLINE
	GREASE TRAP		CENTRAL ANGLE	---	CONTINUOUS
	SANITARY SEWER MANHOLE		DUCTILE IRON PIPE	--- D ---	FENCE LINE
	CATCH BASIN		EAST/EASTING	--- GAS ---	GAS LINE
	STORM DRAINAGE MANHOLE		ELEVATION	-----	EASEMENT
	MITERED END SECTION		FOUND	--- OE ---	OVERHEAD ELECTRICAL LINE
	YARD DRAIN		HANDICAPPED	---	DRAINAGE PIPE
	FOUND BRASS OR ALUMINUM DISK		HIGH DENSITY POLYETHYLENE PIPE	---	BUILDING LINE
	FOUND CONCRETE MONUMENT		INVERT	---	EDGE OF PAVEMENT
	FOUND IRON PIPE		ARC LENGTH	---	EDGE OF WATER
	FOUND IRON ROD		LICENSED BUSINESS	---	CONCRETE
	FOUND NAIL & DISK		LICENSED SURVEYOR	---	BRICK PAVERS
	FOUND X-CUT		LANDSCAPED AREA	---	RIPRAP
				---	DIRT/GRAVEL ROAD

LEGAL DESCRIPTION:



CITRUS BOWL PLAT BOOK 25, PAGE 30 PART OF LOT 1 AND PART OF LOT 1 OF CITRUS BOWL SECOND ADDITION ACCORDING TO PLAT BOOK 26, PAGE 116 DESCRIBED AS: COMMENCING FROM THE SOUTH QUARTER CORNER OF SECTION 27-22-29 THENCE RUN NORTH 89°23'00" WEST A DISTANCE OF 50 FEET TO A POINT ON THE WEST RIGHT-OF-WAY LINE OF SOUTH RIO GRANDE AVENUE FOR A POINT OF BEGINNING. THENCE RUN SOUTH 1°04'12" WEST A DISTANCE OF 410.74 FEET, THENCE NORTH 89°23'00" WEST A DISTANCE OF 850 FEET, THENCE NORTH 01°04'12" EAST FOR A DISTANCE OF 410.74 FEET, THENCE NORTH 00°28'17" EAST FOR A DISTANCE OF 618.92 FEET TO A POINT ON THE SOUTH RIGHT-OF-WAY LINE OF WEST CHURCH STREET, THENCE RUN EAST ALONG THE SAID SOUTH RIGHT-OF-WAY LINE OF WEST CHURCH STREET A DISTANCE OF 850 FEET TO A POINT ON THE WEST RIGHT OF WAY LINE OF SOUTH RIO GRANDE AVENUE, THENCE RUN SOUTH 00°28'17" WEST A DISTANCE OF 624.26 FEET TO THE POINT OF BEGINNING. (LESS LEASED SKY BOXES) SEE ORLANDO RESOLUTION #070618702.

SHEET INDEX:

V-100	SURVEYOR'S NOTES, KEY MAP, VICINITY MAP
V-101 - V-102	BOUNDARY SURVEY
V-201 - V-212	TOPOGRAPHIC SURVEY

KEY MAP: NOT TO SCALE

VICINITY MAP: NOT TO SCALE

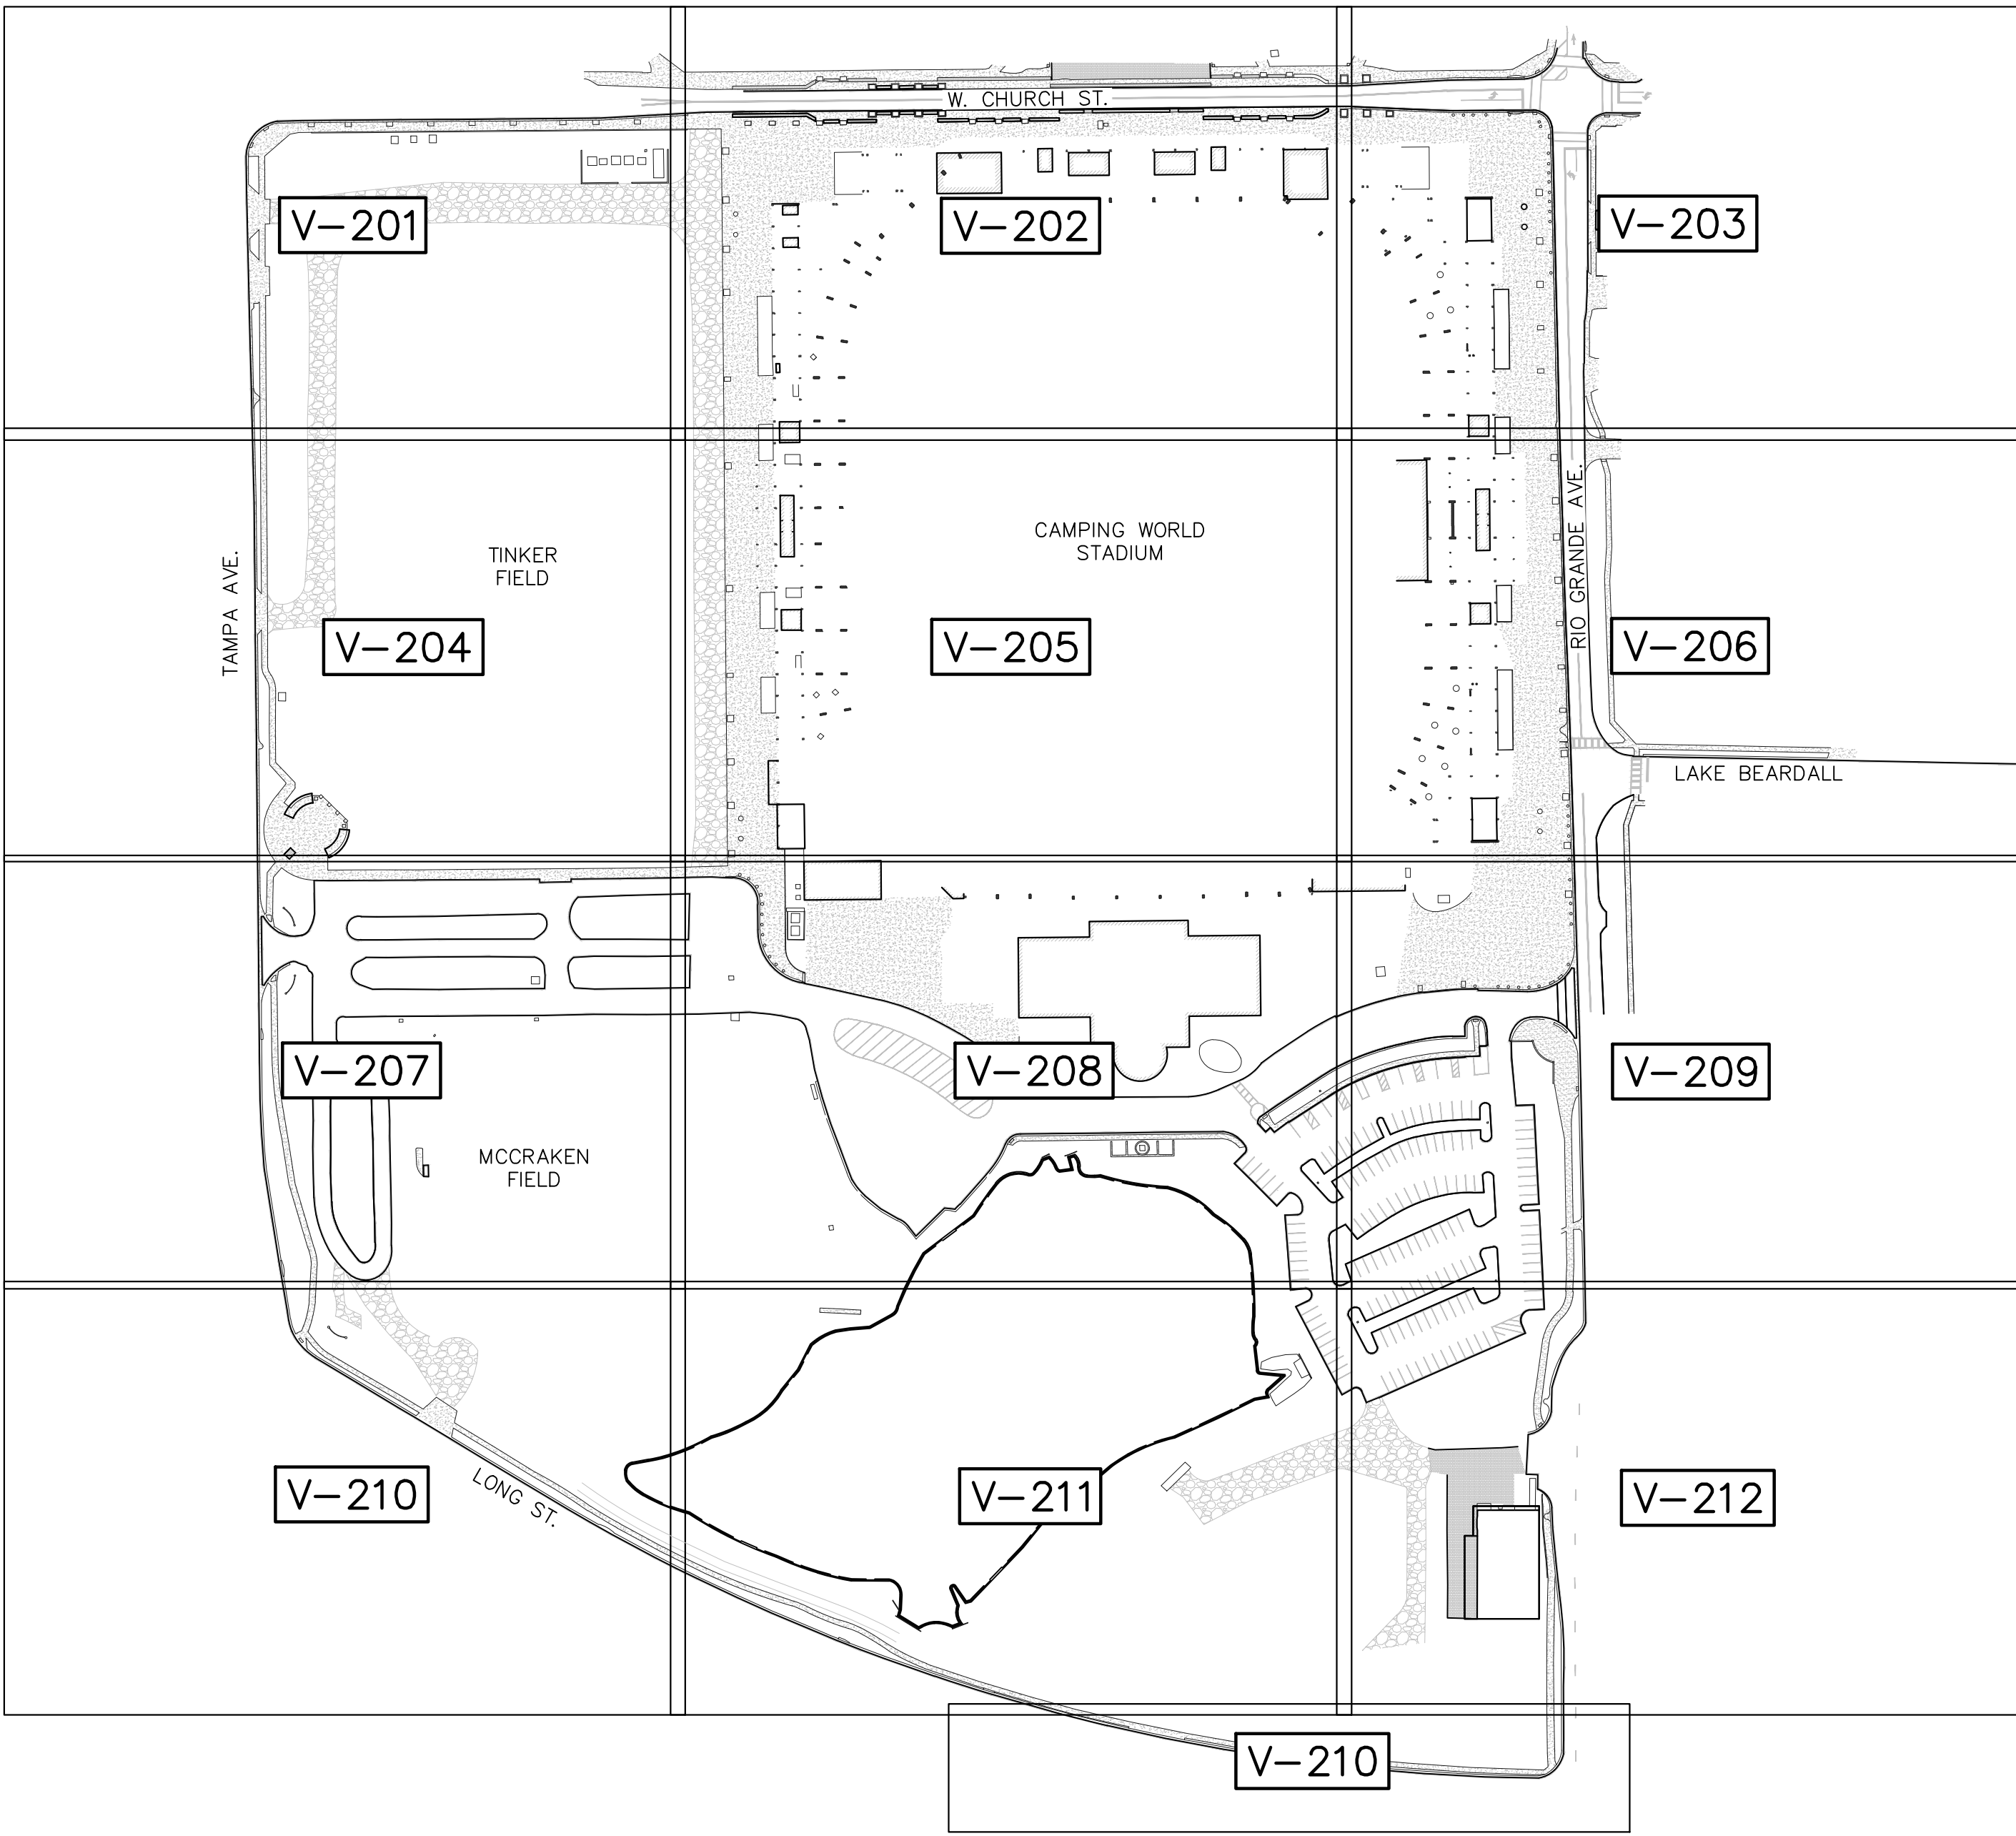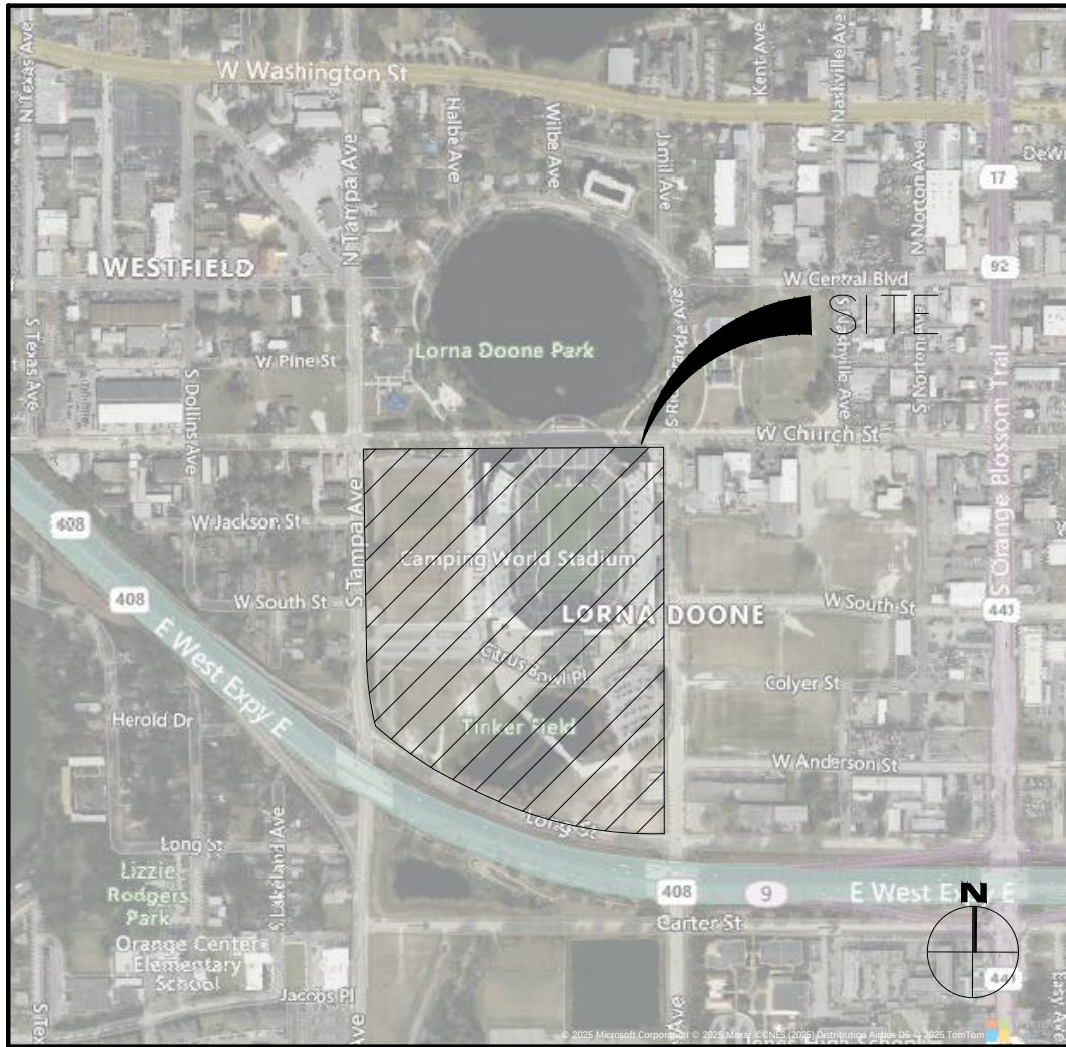

SURVEYOR'S CERTIFICATION
I HEREBY CERTIFY THAT THIS SURVEY REPRESENTED HEREON IS TRUE AND CORRECT TO THE BEST OF MY KNOWLEDGE, INFORMATION, AND BELIEF. IT HAS BEEN PREPARED IN ACCORDANCE WITH THE STANDARDS SET FORTH IN CHAPTER 5J-17 OF THE FLORIDA ADMINISTRATIVE CODE (F.A.C.) AND IN CHAPTERS 177 AND 472 OF THE FLORIDA STATUTES. THIS SURVEY MAP AND/OR REPORT IS VOID WITHOUT THE SIGNATURE AND THE ORIGINAL RAISED SEAL OR THE ELECTRONIC SIGNATURE IN COMPLIANCE WITH F.A.C. 5J-17.602(3) OF THE SIGNING SURVEYOR AND MAPPER.

SHIRLEY LEE MANOR, PSM - LSV 6961

CAMPING WORLD STADIUM

DLR GROUP

COVER

LOCATED IN



SECTIONS 27 & 34, TOWNSHIP 22 SOUTH, RANGE 29 EAST
CITY OF ORLANDO
ORANGE COUNTY, FLORIDA

REVISIONS			
No.	DATE	BY	DESCRIPTION

PROJECT No.	1250009
SURVEY BY	MC
SURVEY DATE	2025 APRIL 24
DRAWN BY	BSAC
DRAWN DATE	2025 MAY 06
REVIEWED BY	SM
APPROVED BY	SM

DRAWING No.
V-100
SHEET
1 OF 15


L & S Diversified
4776 NEW BRIDGE STREET | SUITE 200 | ORLANDO, FL 32834
PHONE 407.802.3036
WWW.LSURLSURVEYOR.COM | INFO@LSURLSURVEYOR.COM
PROFESSIONAL SURVEYOR & MAPPER BUSINESS LICENSE | L187023

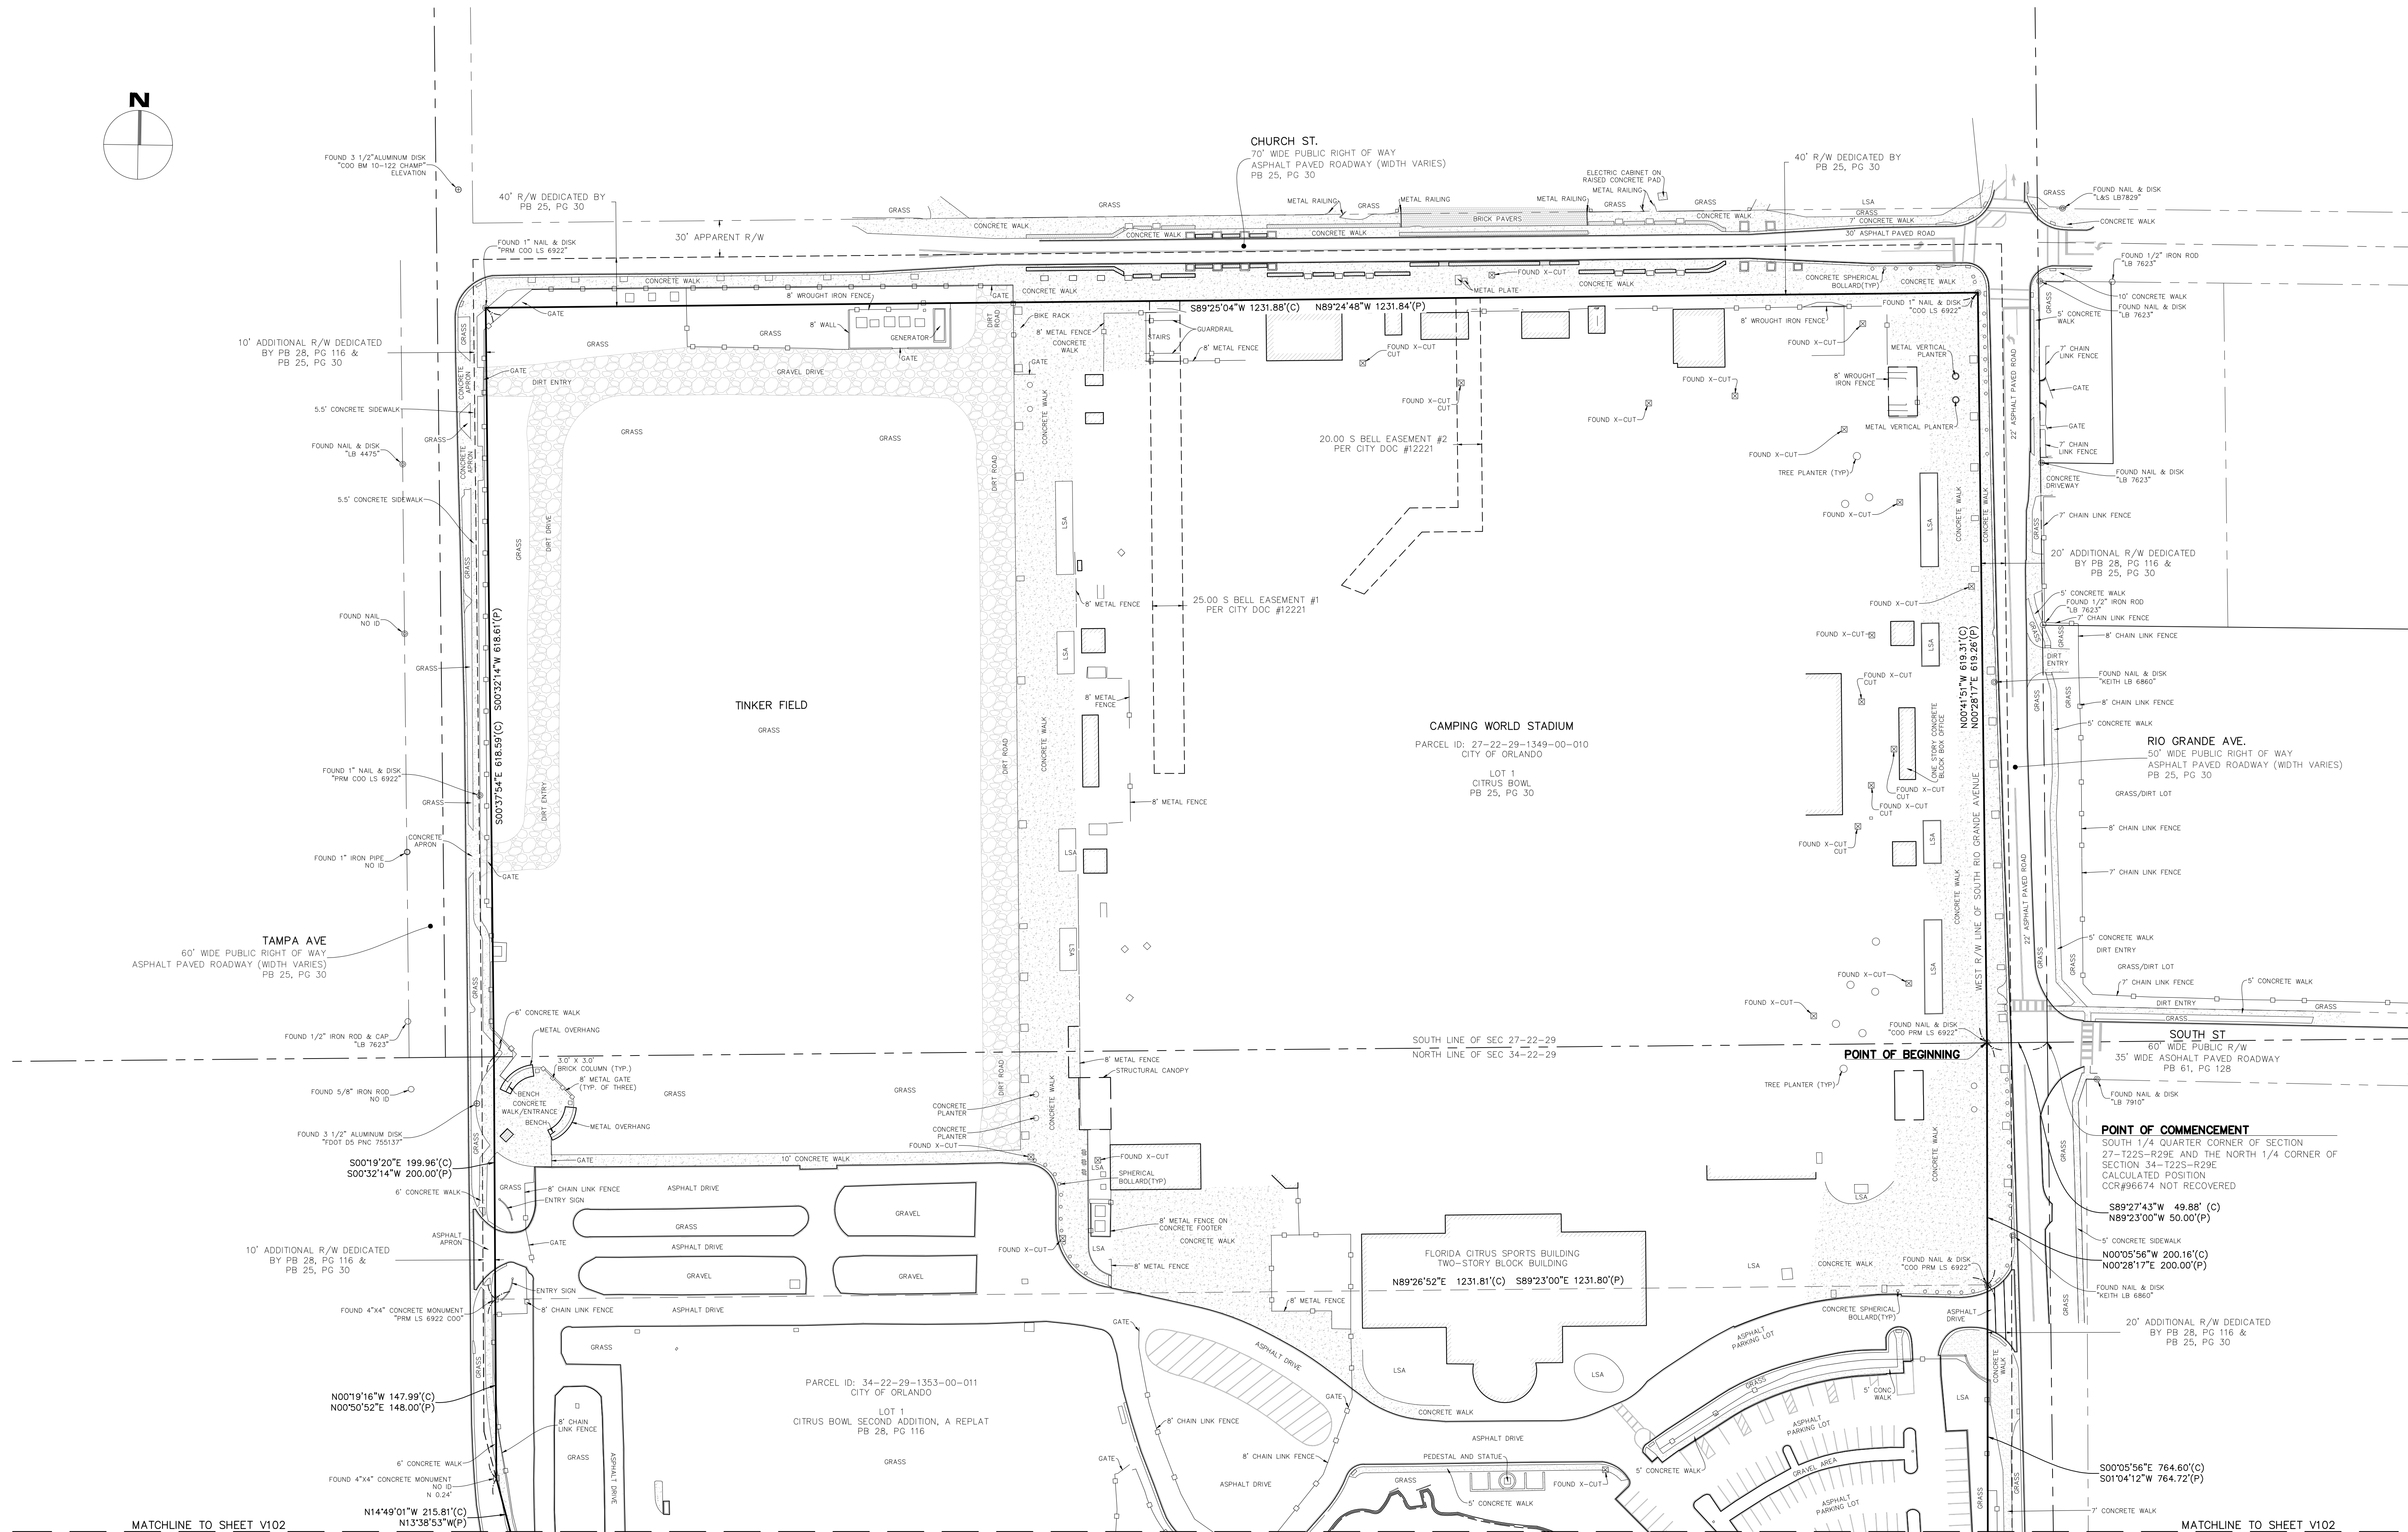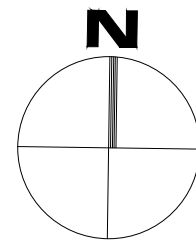

*FOR BOUNDARY DETAILS SEE SHEETS V-201 - V-212

CAMPING WORLD STADIUM
DLR GROUP
BOUNDARY SURVEY

LOCATED IN
SECTIONS 27 & 34, TOWNSHIP 22 SOUTH, RANGE 29 EAST
CITY OF ORLANDO
ORANGE COUNTY, FLORIDA

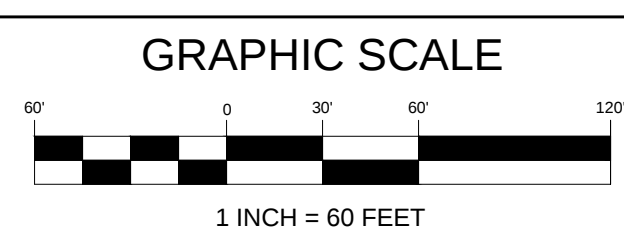

NO.	DATE	BY	DESCRIPTION

REVISIONS



PROJECT No.	1250009
SURVEY DATE	MC
DRAWN BY	2025 APRIL 24
DRAWN DATE	BSAC
REVIEWED BY	2025 MAY 06
APPROVED BY	SM

DRAWING No.	V-101
SHEET	2 OF 15

L & S Diversified
4716 NEW BRIDGE STREET, SUITE 100 | ORLANDO, FL 32834
PHONE 407.802.3036
WWW.LSURVEYOR.COM | INFO@LSURVEYOR.COM
PROFESSIONAL SURVEYOR & MAPPER BUSINESS LICENSE | LB18702

MATCHLINE TO SHEET V101


MATCHLINE TO SHEET V101

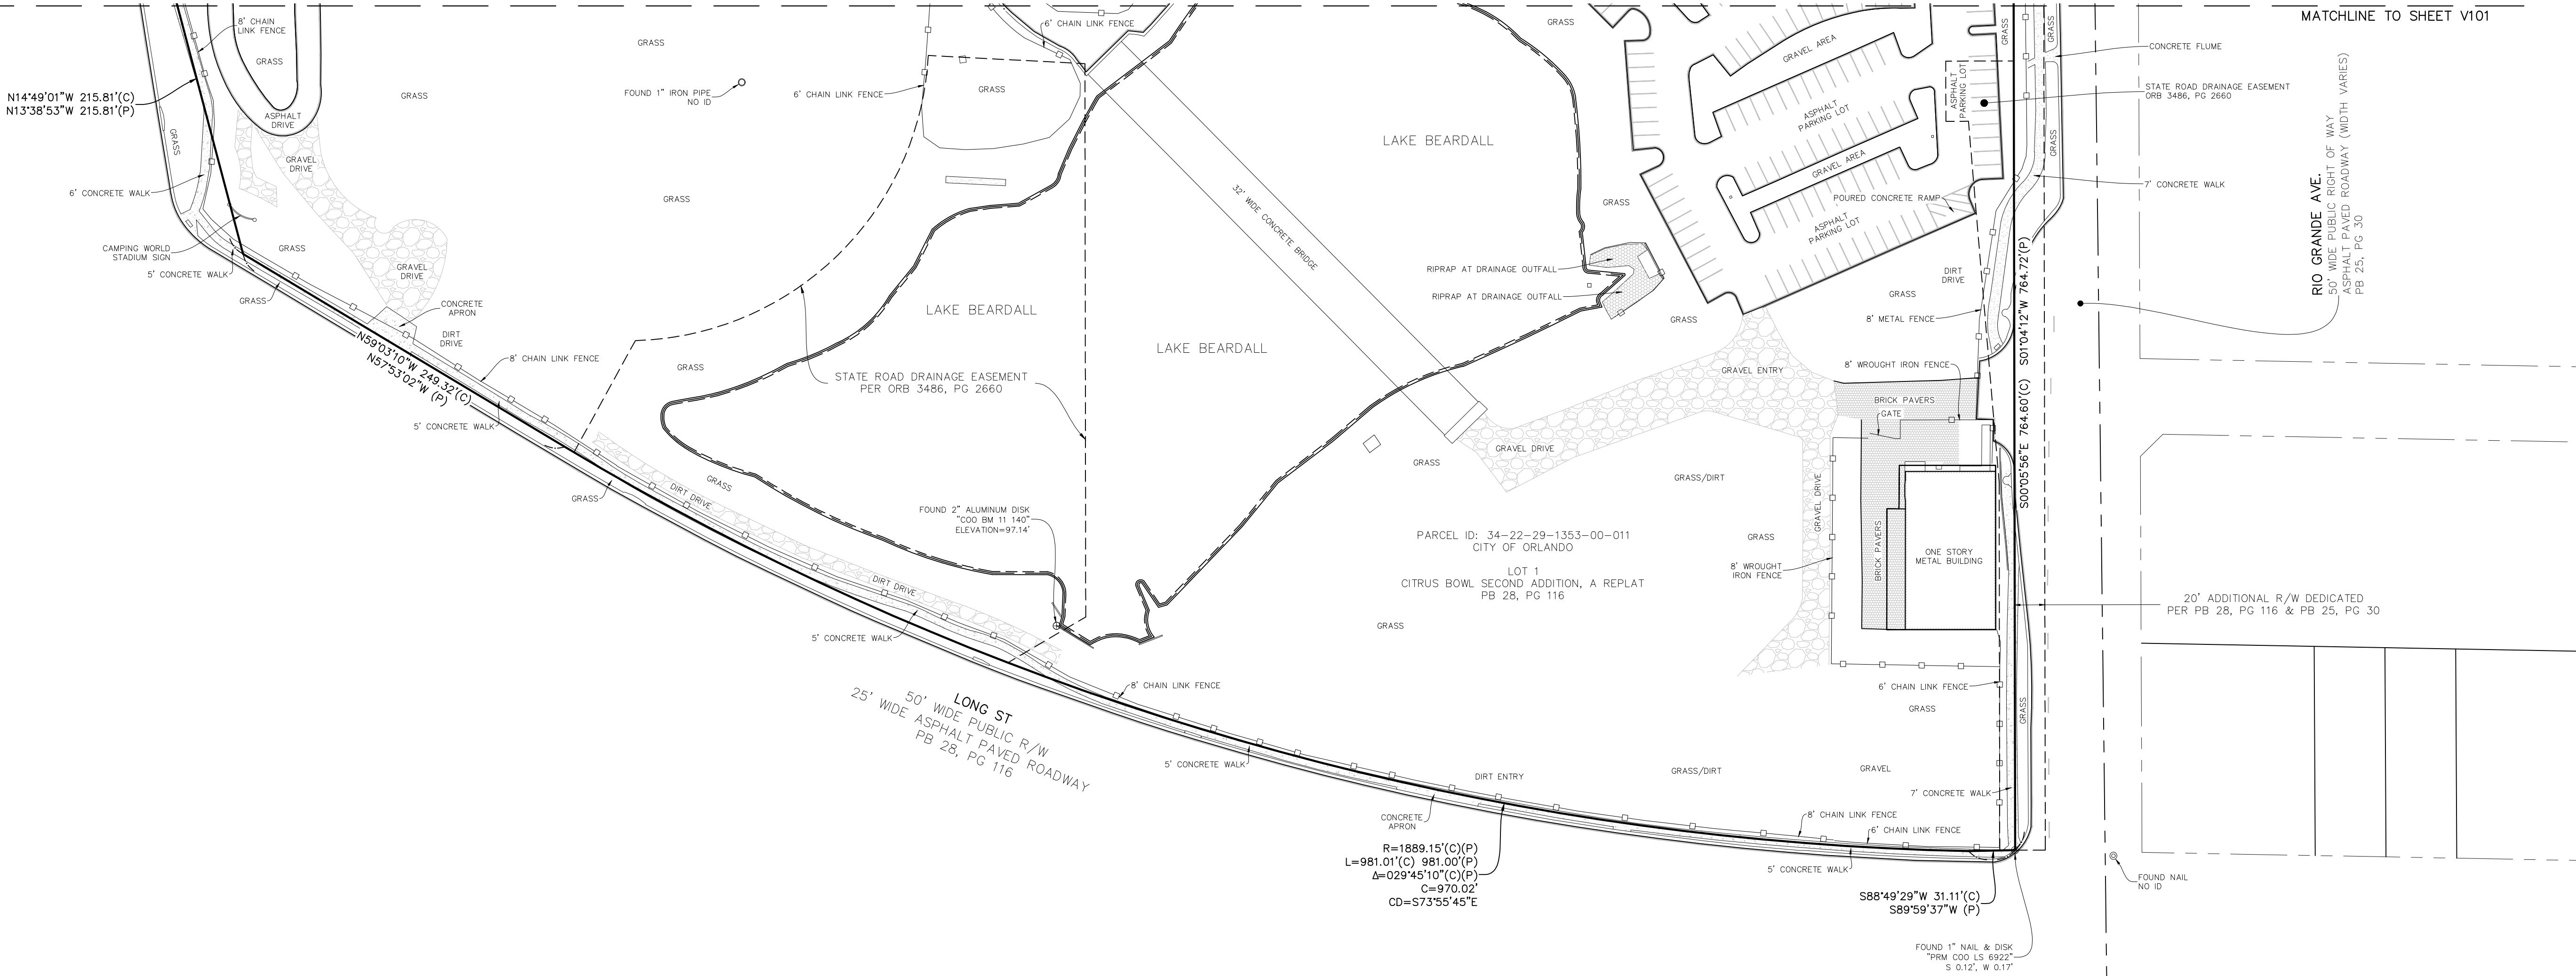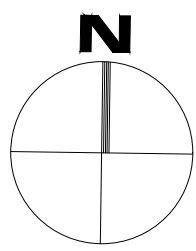

*FOR BOUNDARY DETAILS SEE SHEETS V-201 - V-212

CAMPING WORLD STADIUM
DLR GROUP
BOUNDARY SURVEY

LOCATED IN
SECTIONS 27 & 34, TOWNSHIP 22 SOUTH, RANGE 29 EAST
CITY OF ORLANDO
ORANGE COUNTY, FLORIDA

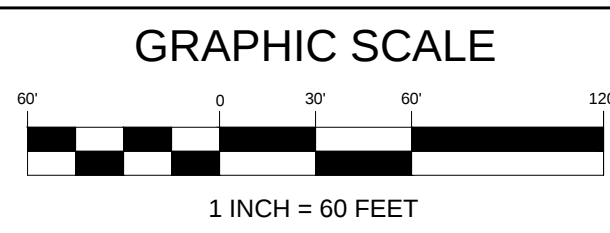


REVISIONS			
No.	DATE	BY	DESCRIPTION

PROJECT No.	1250009
SURVEY BY	MC
SURVEY DATE	2025 APRIL 24
DRAWN BY	BSAC
DRAWN DATE	2025 MAY 06
REVIEWED BY	SM
APPROVED BY	SM

DRAWING No.
V-102

SHEET
3 OF 15

**L & S
Diversified**
PROFESSIONAL SURVEYING & MAPPING
4776 NEW BRIDGE STREET | SUITE 100 | ORLANDO, FL 32834
PHONE 407.802.3535
WWW.LSURVEYOR.COM | INFO@LSURVEYOR.COM
PROFESSIONAL SURVEYOR & MAPPER BUSINESS LICENSE 1 LB17029

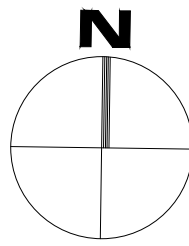

TAMPA AVE.
60' WIDE PUBLIC RIGHT OF WAY
ASPHALT PAVED ROADWAY (WIDTH VARIES)
PER CITY OF ORLANDO PB 25, PG 30

CHURCH ST.
60' WIDE PUBLIC RIGHT OF WAY
ASPHALT PAVED ROADWAY (WIDTH VARIES)
PER CITY OF ORLANDO PB 25, PG 30


PARCEL ID: 27-22-29-1349-00-010
CITY OF ORLANDO
LOT 1
CITRUS BOWL
PB 25, PG 30

MATCHLINE TO SHEET V-204

MATCHLINE TO SHEET V-204

CAMPING WORLD STADIUM
DLR GROUP
TOPOGRAPHIC SURVEY

LOCATED IN
SECTIONS 27 & 34, TOWNSHIP 22 SOUTH, RANGE 29 EAST
CITY OF ORLANDO
ORANGE COUNTY, FLORIDA

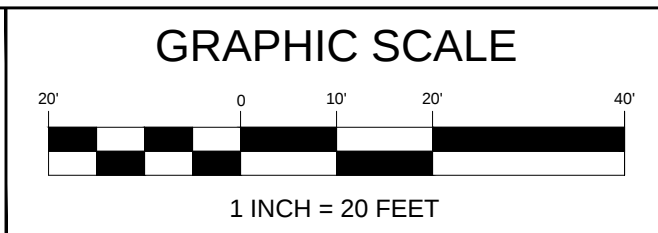

REVISIONS			
No.	DATE	BY	DESCRIPTION

PROJECT No.	1250009
SURVEY BY	MC
SURVEY DATE	2025 APRIL 24
DRAWN BY	BSAC
DRAWN DATE	2025 MAY 06
REVIEWED BY	SM
APPROVED BY	SM

DRAWING No.	V-201
SHEET	4 OF 15


L & S Diversified

PROFESSIONAL SURVEYOR & MAPPER BUSINESS LICENSE | LB17829

4776 NEW WOOD STREET | SUITE 100 | ORLANDO, FL 32834
PHONE 407.802.3535
WWW.LSURVEYOR.COM | INFO@LSURVEYOR.COM

MATCHLINE TO SHEET V-201

MATCHLINE TO SHEET V-201

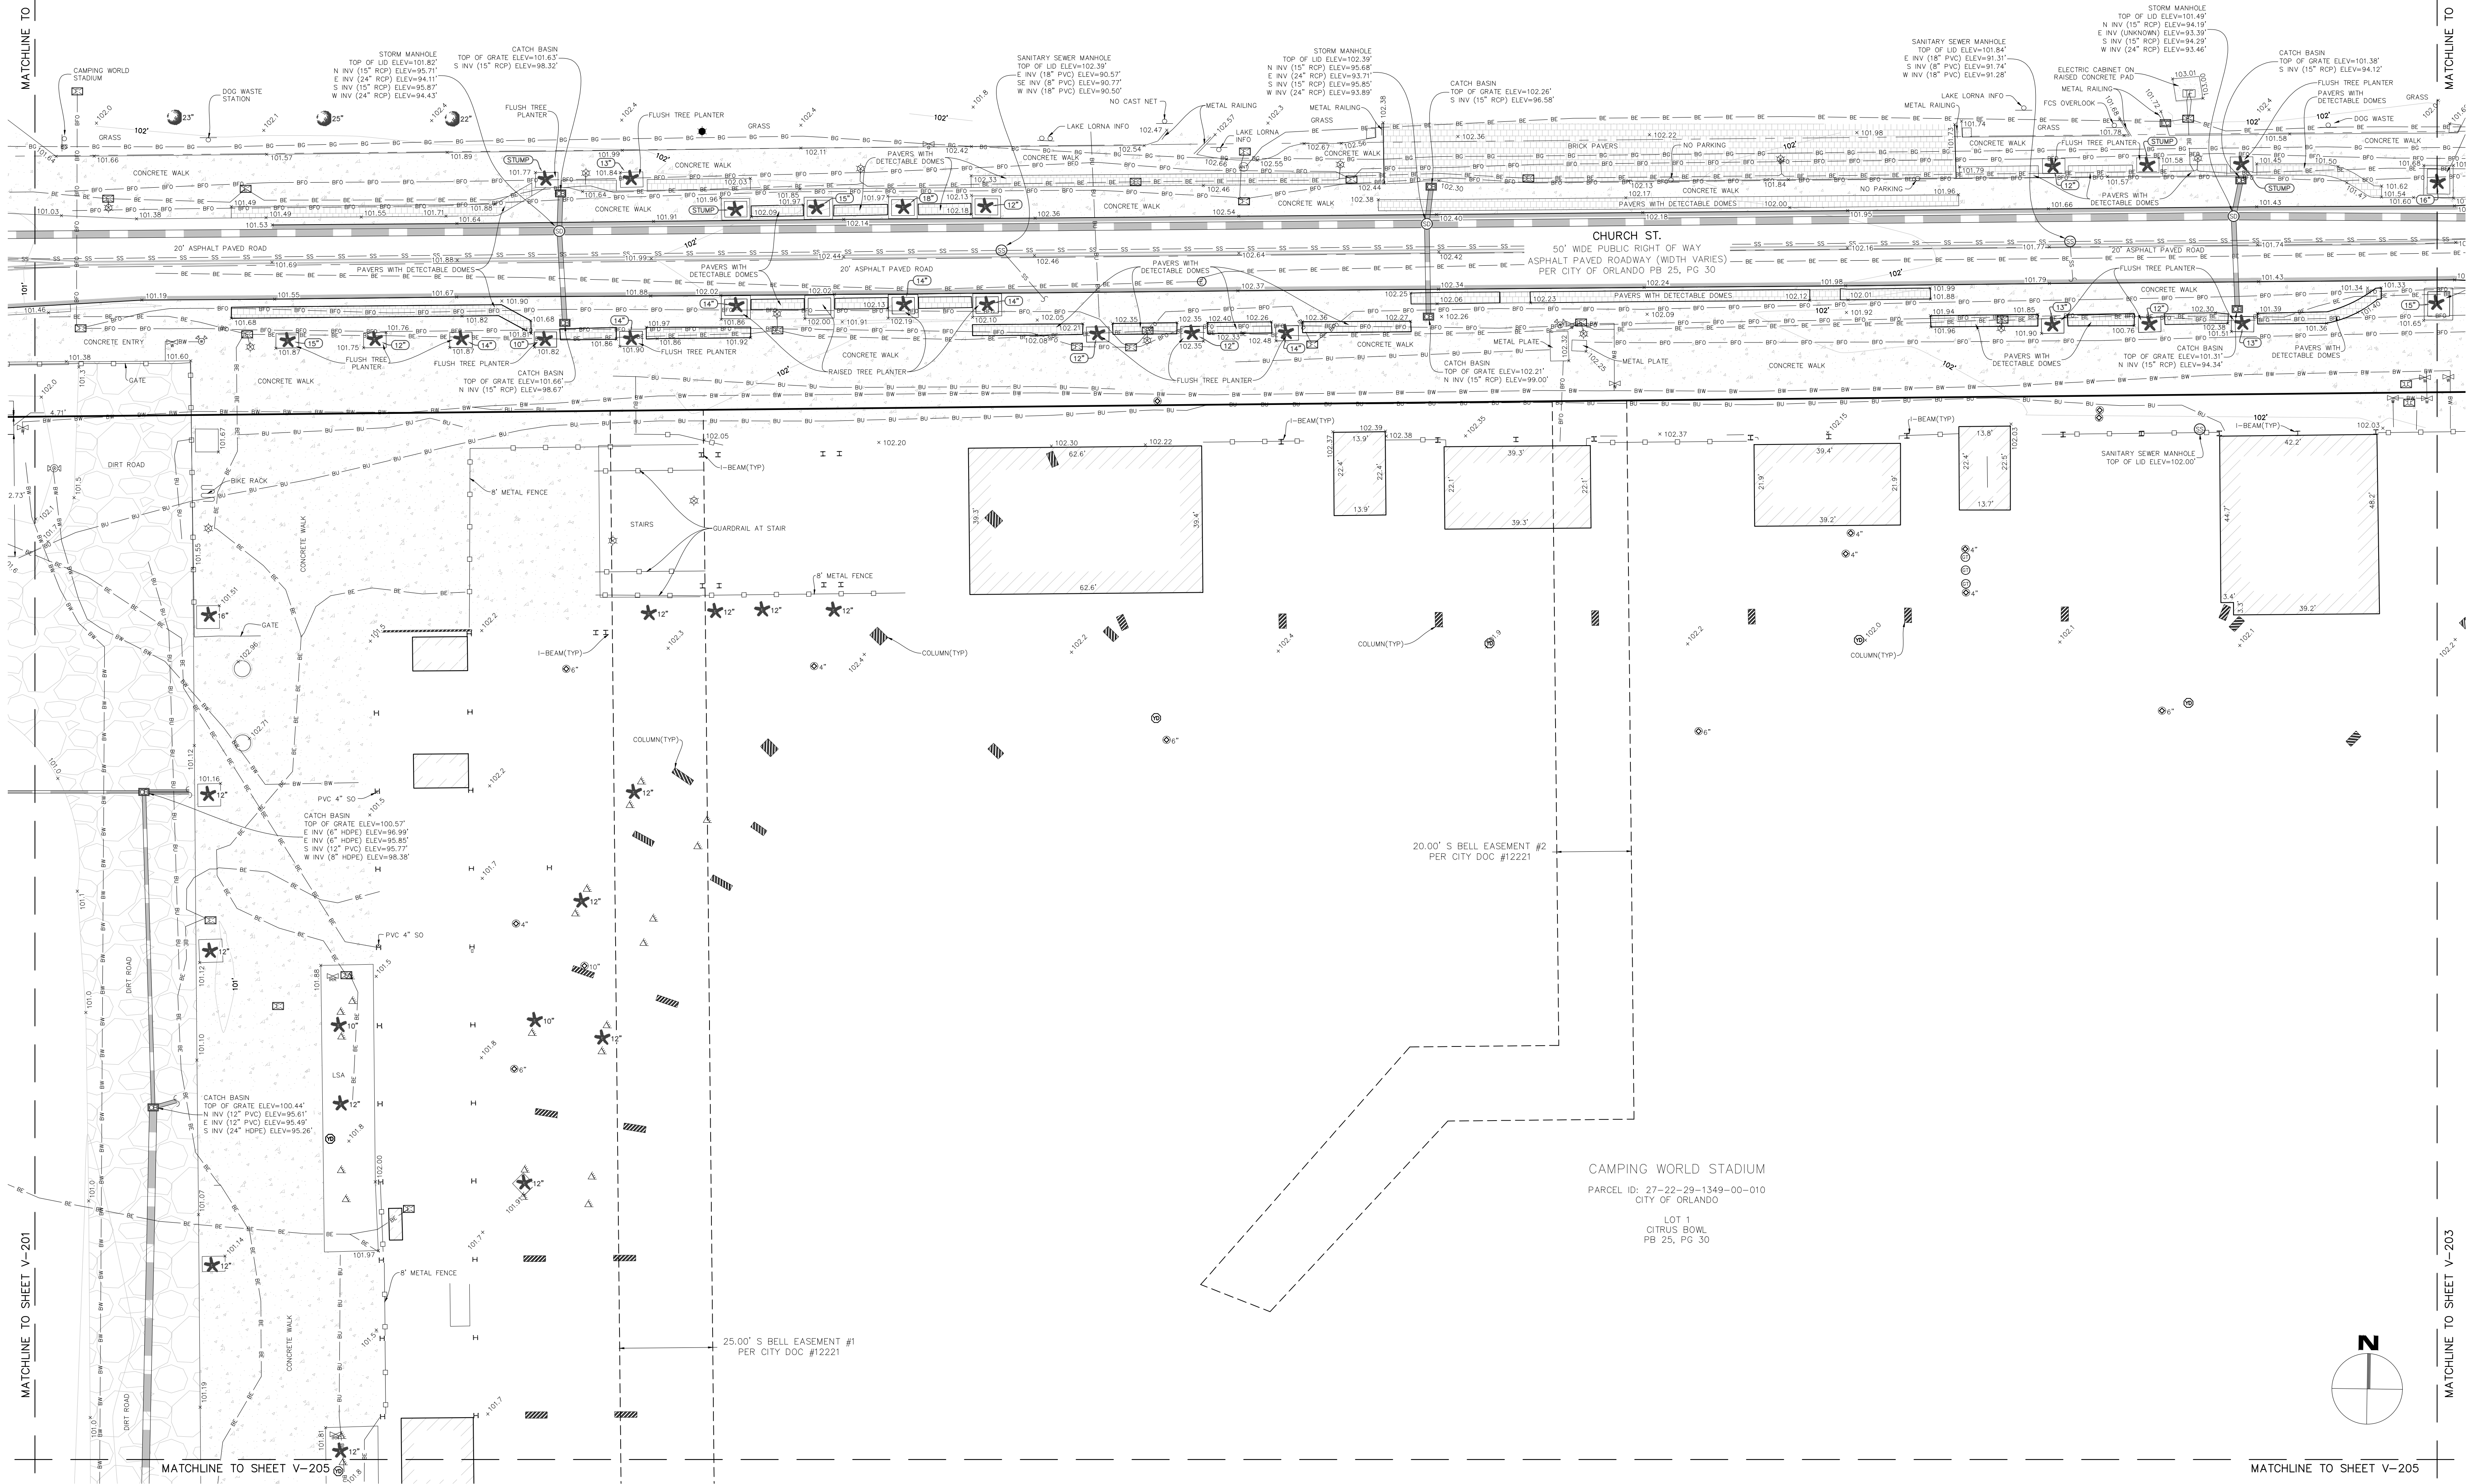


MATCHLINE TO SHEET V-203

MATCHLINE TO SHEET V-203

CAMPING WORLD STADIUM
DLR GROUP
TOPOGRAPHIC SURVEY

LOCATED IN
SECTIONS 27 & 34, TOWNSHIP 22 SOUTH, RANGE 29 EAST
CITY OF ORLANDO
ORANGE COUNTY, FLORIDA

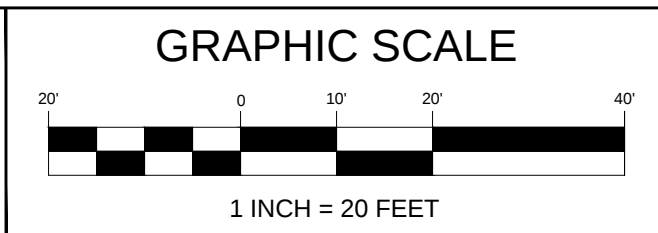


No.	DATE	BY	DESCRIPTION

PROJECT No.	1250009
SURVEY BY	MC
SURVEY DATE	2025 APRIL 24
DRAWN BY	BSAC
DRAWN DATE	2025 MAY 06
REVIEWED BY	SM
APPROVED BY	SM

DRAWING No.
V-202
SHEET
5 OF 15

L & S
Diversified
4786 NEW WOOD STREET | SUITE 100 | ORLANDO, FL 32834
PHONE 407.802.3036
WWW.LSURVEYOR.COM | INFO@LSURVEYOR.COM
PROFESSIONAL SURVEYOR & MAPPER BUSINESS LICENSE | 187829

MATCHLINE TO SHEET V-202

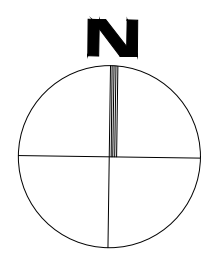

L & S
Diversified
 Professional Surveyors and Mappers
 4776 NW BROAD STREET | SUITE 100 | ORLANDO, FL 32814
 PHONE: 407.681.3836
 WWW.LSSURVEYOR.COM | INFO@LSSURVEYOR.COM

MATCHLINE TO SHEET V-205


MATCHLINE TO SHEET V-205

MATCHLINE TO SHEET V-203

MATCHLINE TO SHEET V-203


MATCHLINE TO SHEET V-209

MATCHLINE TO SHEET V-209

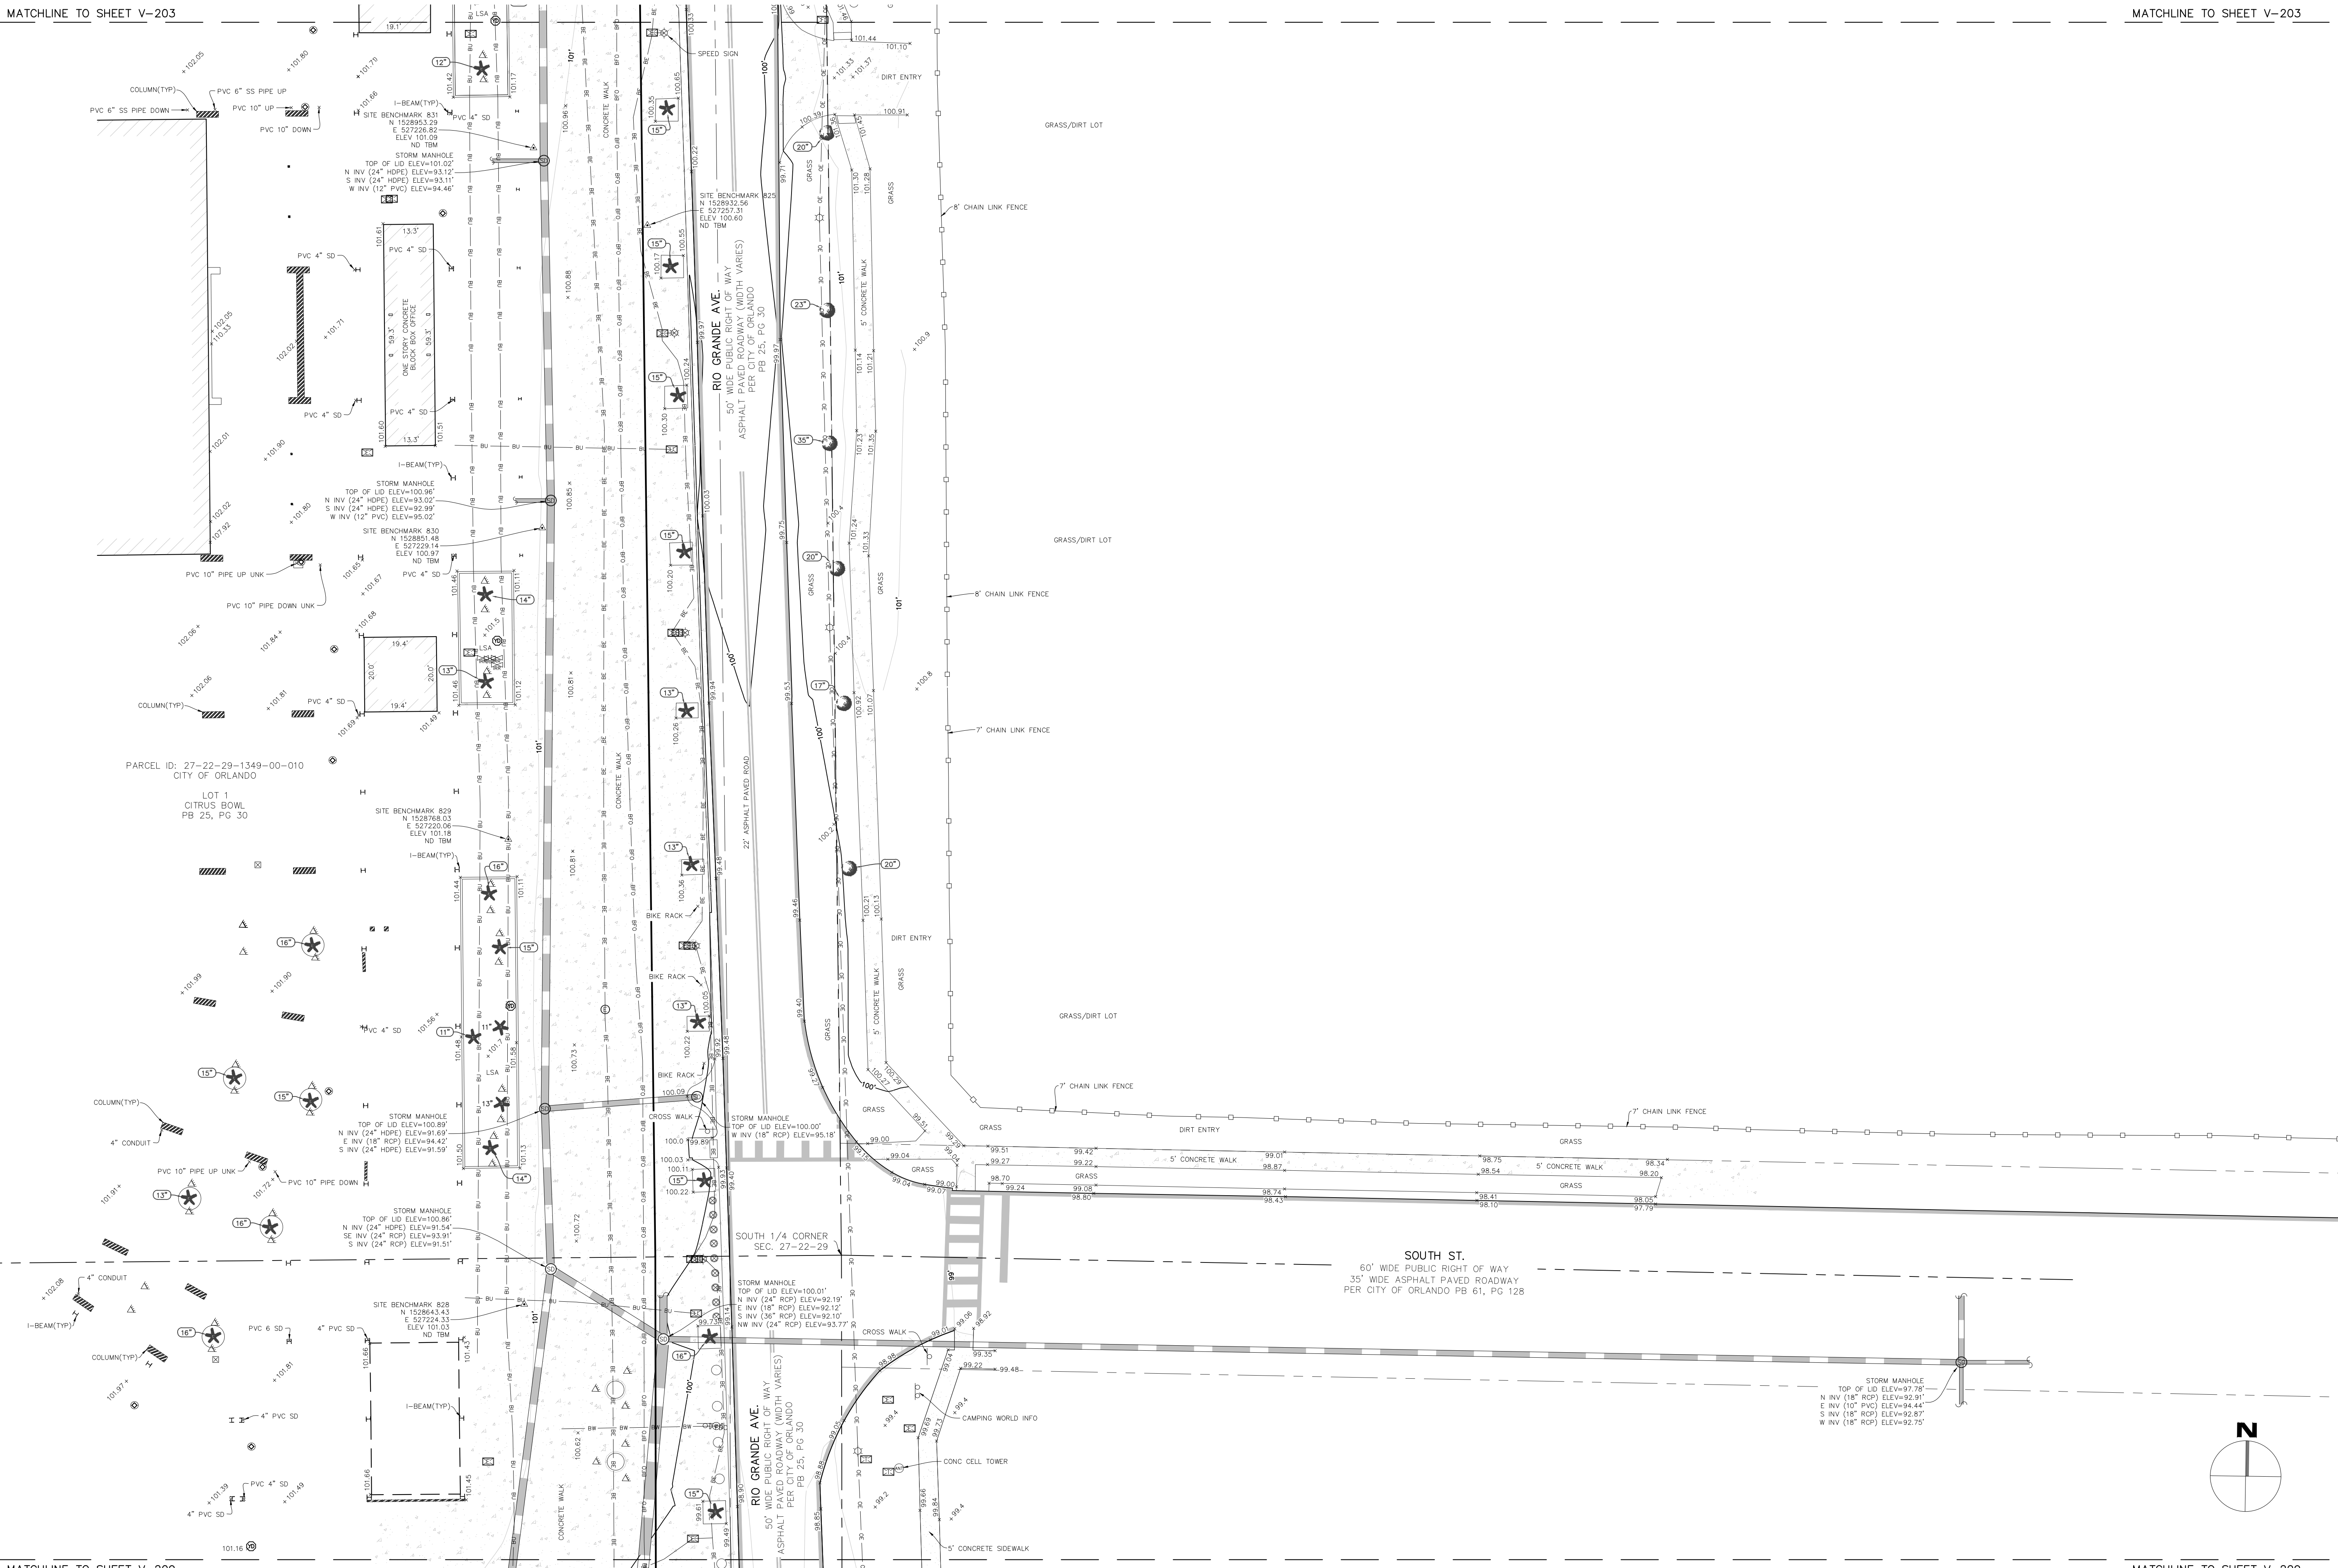

CAMPING WORLD STADIUM
DLR GROUP
TOPOGRAPHIC SURVEY

LOCATED IN
SECTIONS 27 & 34, TOWNSHIP 22 SOUTH, RANGE 29 EAST
CITY OF ORLANDO
ORANGE COUNTY, FLORIDA

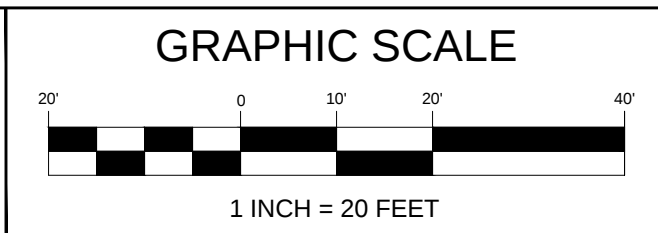


REVISIONS			
No.	DATE	BY	DESCRIPTION

PROJECT No.	1250009
SURVEY DATE	MC
DRAWN BY	2025 APRIL 24
DRAWN DATE	BSAC
APPROVED BY	2025 MAY 06
APPROVED BY	SM

DRAWING No.	V-206
SHEET	9 OF 15


L & S Diversified
PROFESSIONAL SURVEYOR & MAPPER BUSINESS LICENSE 1817022

4776 NEW WOOD STREET | SUITE 200 | ORLANDO, FL 32834
PHONE 407.802.3535
WWW.LSURVEYOR.COM | INFO@LSURVEYOR.COM

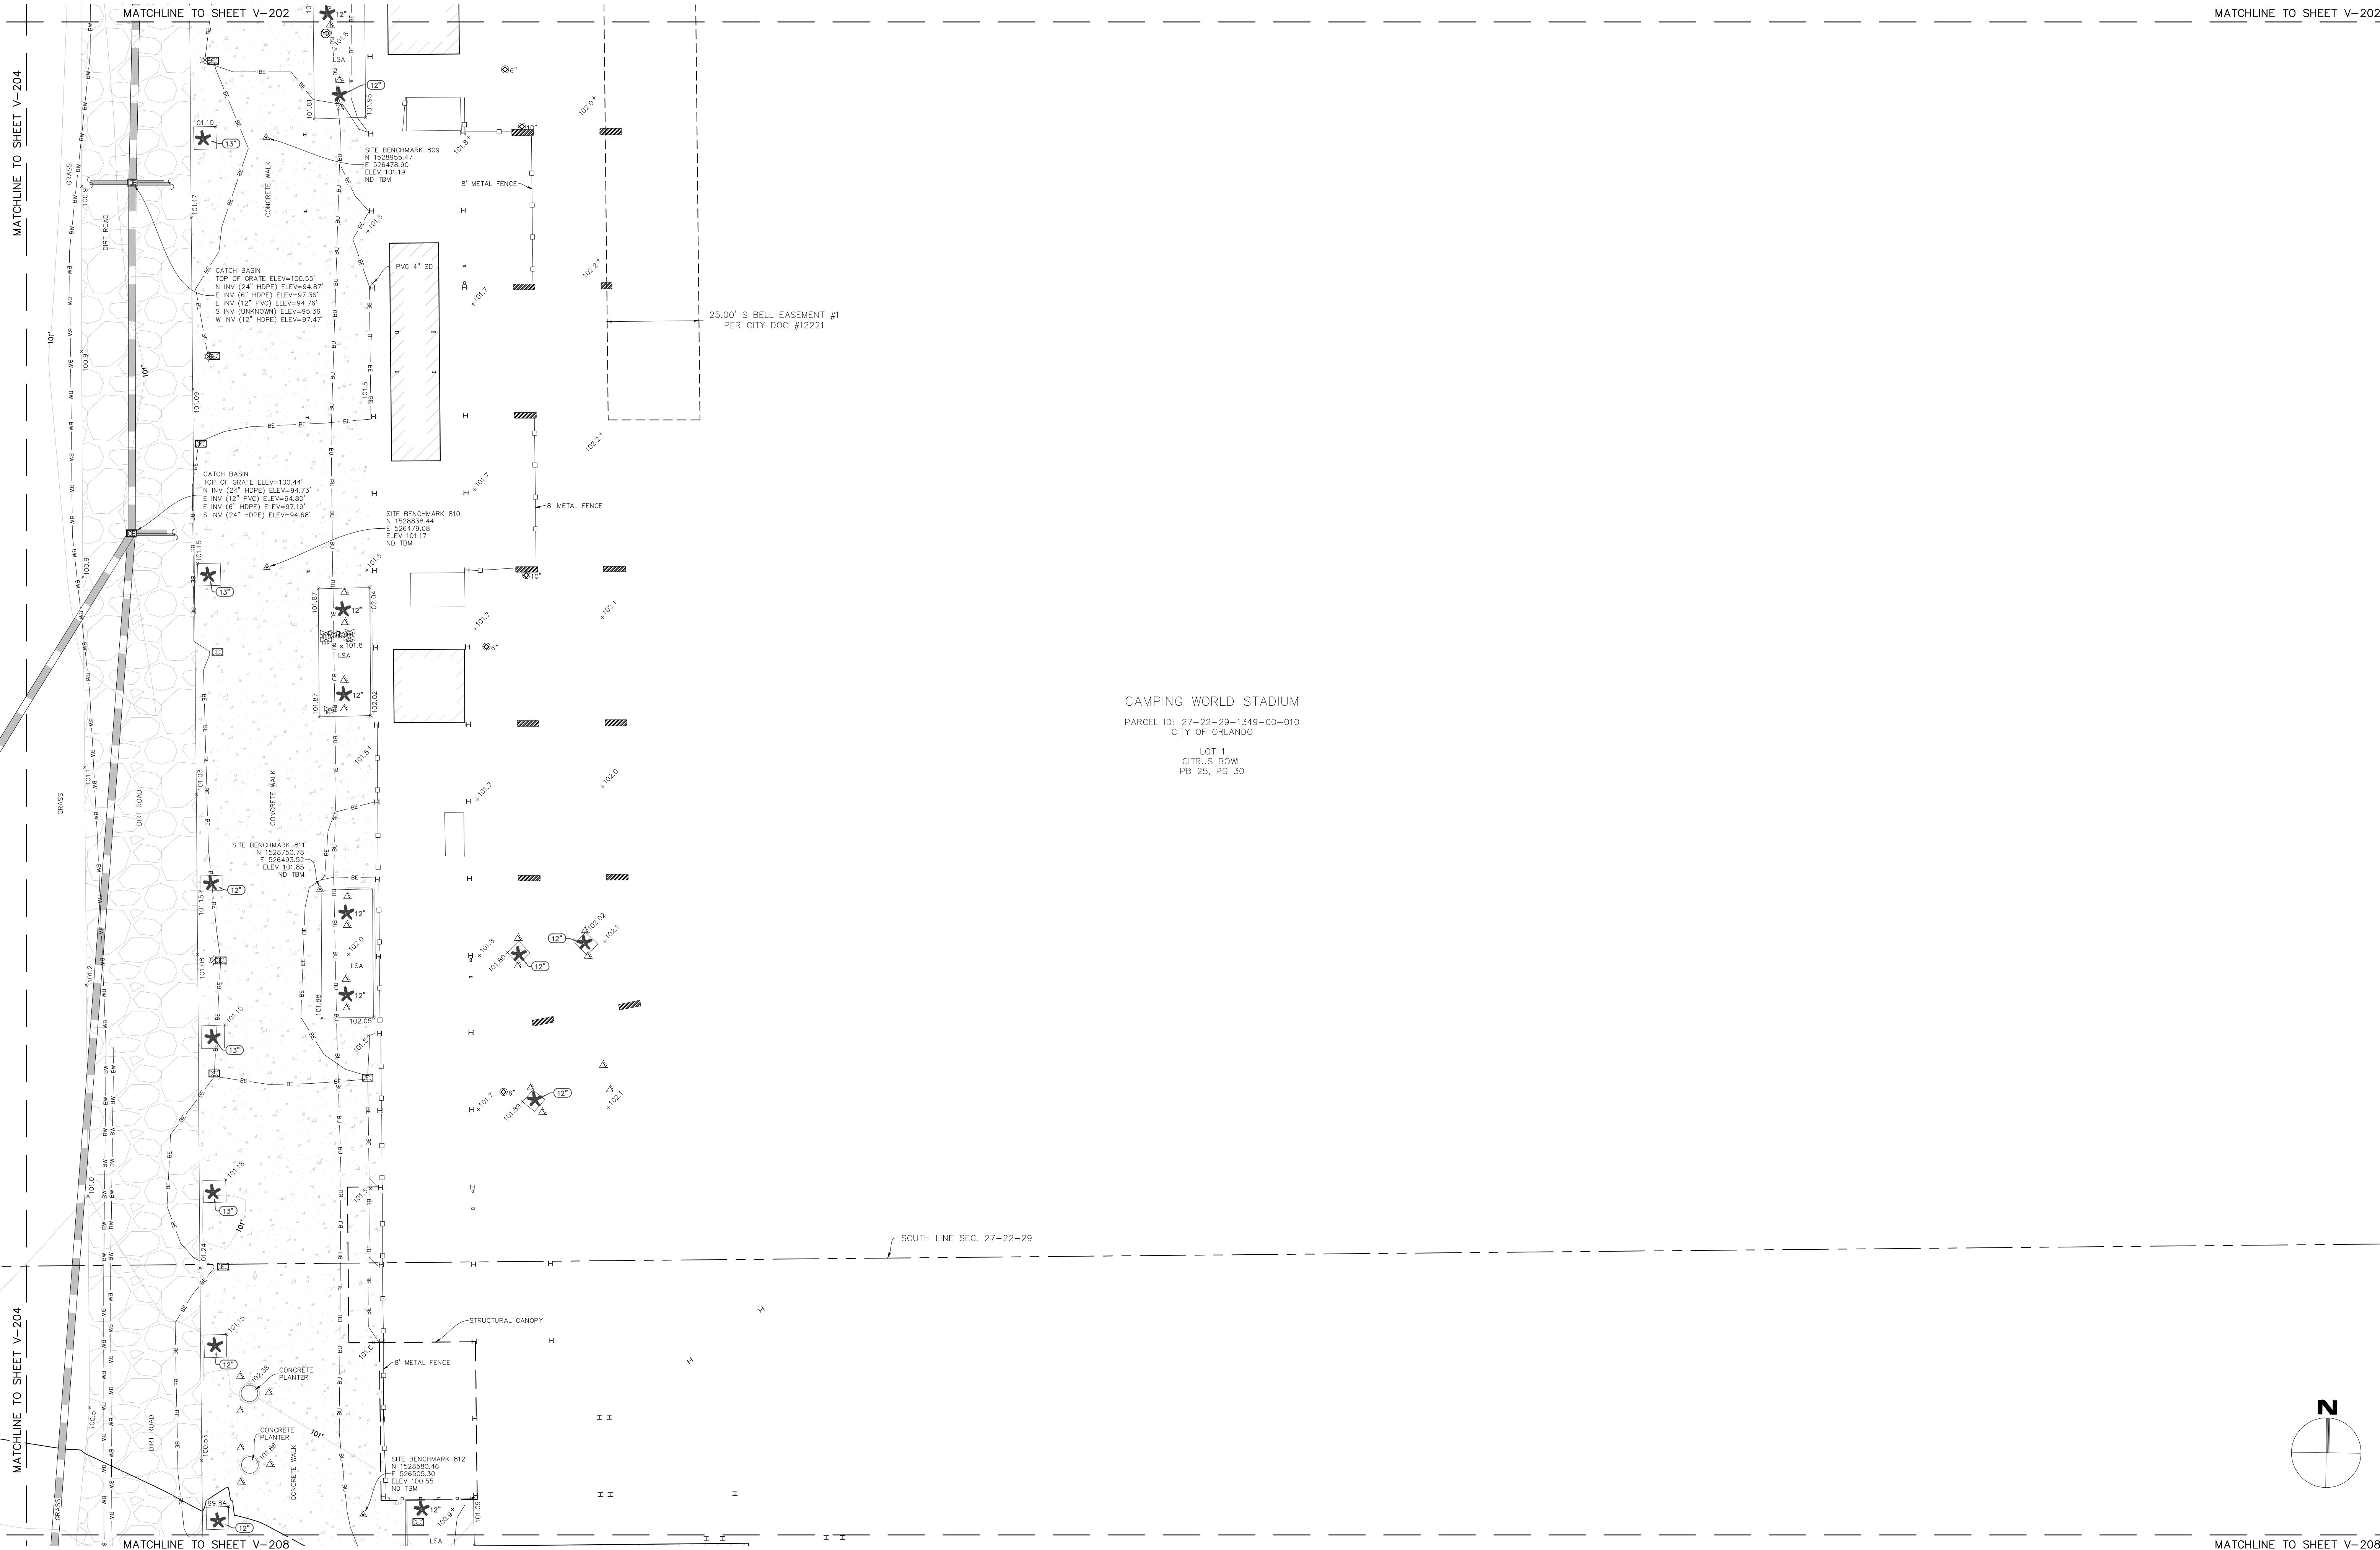

CAMPING WORLD STADIUM
DLR GROUP
TOPOGRAPHIC SURVEY

LOCATED IN
SECTIONS 27 & 34, TOWNSHIP 22 SOUTH, RANGE 29 EAST
CITY OF ORLANDO
ORANGE COUNTY, FLORIDA

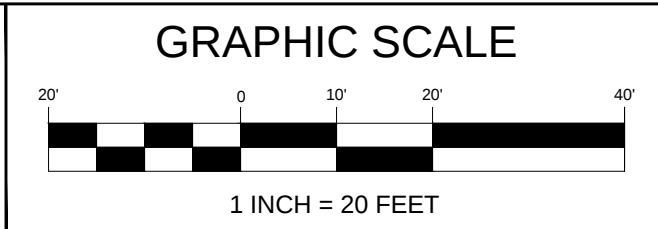


REVISIONS			
No.	DATE	BY	DESCRIPTION

PROJECT No.	1250009
SURVEY BY	MC
SURVEY DATE	2025 APRIL 24
DRAWN BY	BSAC
DRAWN DATE	2025 MAY 06
REVIEWED BY	SM
APPROVED BY	SM

DRAWING No.
V-205
SHEET
8 OF 15

L & S Diversified
4794 NEW WOOD STREET | SUITE 200 | ORLANDO, FL 32834
PHONE 407.802.3536
WWW.LSURVEYOR.COM | INFO@LSURVEYOR.COM
PROFESSIONAL SURVEYOR & MAPPER BUSINESS LICENSE | LB17029

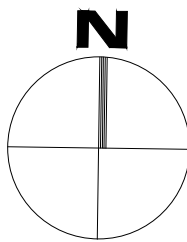

SANITARY SEWER MANHOLE
TOP OF LID ELEV=101.86'
N INV (4" VCP) ELEV=96.03'
E INV (6" VCP) ELEV=94.59'
W INV (6" VCP) ELEV=94.61'

SANITARY SEWER MANHOLE
TOP OF LID ELEV=101.73'
E INV (6" PVC) ELEV=93.41'
S INV (8" VCP) ELEV=96.61'
W INV (8" VCP) ELEV=93.43'

MATCHLINE TO SHEET V-201

SANITARY SEWER MANHOLE
TOP OF LID ELEV=101.15'
E INV (8" PVC) ELEV=90.18'
W INV (6" VCP) ELEV=91.89'

SANITARY SEWER MANHOLE
TOP OF LID ELEV=101.51'
N INV (UNKNOWN) ELEV=88.12'
S INV (UNKNOWN) ELEV=88.09'
W INV (8" PVC) ELEV=89.20'

TAMPA AVE.
60' WIDE PUBLIC RIGHT OF WAY
ASPHALT PAVED ROADWAY (WIDTH VARIES)
PER CITY OF ORLANDO PB 25, PG 30

SANITARY SEWER MANHOLE
TOP OF LID ELEV=100.83'
NE INV (5" PVC) ELEV=96.80'
E INV (UNKNOWN) ELEV=89.41'
W INV (8" PVC) ELEV=89.43'

SANITARY SEWER MANHOLE
TOP OF LID ELEV=100.69'
N INV (24" PVC) ELEV=88.18'
S INV (24" PVC) ELEV=89.69'
S INV (24" PVC) ELEV=87.99'
W INV (UNKNOWN) ELEV=88.87'

CATCH BASIN
TOP OF GRATE ELEV=101.16'
GRATE NOT ACCESSIBLE
STRUCTURE FULL OF DEBRIS

SITE BENCHMARK 800
N 1028995.84
E 526128.60
ELEV 101.68
RC 1BM

PARCEL ID: 27-22-29-1349-00-010
CITY OF ORLANDO
LOT 1
CITRUS BOWL
PB 25, PG 30

CATCH BASIN
TOP OF GRATE ELEV=101.89'
NE INV (6" PVC) ELEV=97.89'

MATCHLINE TO SHEET V-201

MATCHLINE TO SHEET V-205


MATCHLINE TO SHEET V-205

MATCHLINE TO SHEET V-207

MATCHLINE TO SHEET V-207

CAMPING WORLD STADIUM
DLR GROUP
TOPOGRAPHIC SURVEY

LOCATED IN
SECTIONS 27 & 34, TOWNSHIP 22 SOUTH, RANGE 29 EAST
CITY OF ORLANDO
ORANGE COUNTY, FLORIDA

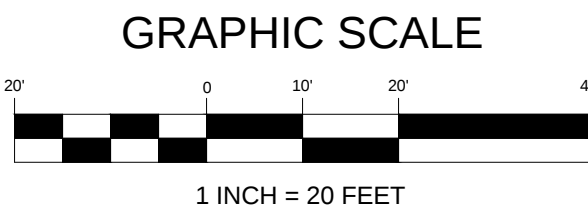

REVISIONS			
No.	DATE	BY	DESCRIPTION

PROJECT No.	1250009
SURVEY BY	MC
SURVEY DATE	2025 APRIL 24
DRAWN BY	BSAC
DRAWN DATE	2025 MAY 06
REVIEWED BY	SM
APPROVED BY	SM



DRAWING No.
V-204
SHEET
7 OF 15



L & S
Diversified
4776 NEW WOOD STREET | SUITE 100 | ORLANDO, FL 32834
PHONE 407.802.3536
WWW.LSURVEYOR.COM | INFO@LSURVEYOR.COM
PROFESSIONAL SURVEYOR & MAPPER BUSINESS LICENSE 1 LB17029

MATCHLINE TO SHEET V-204

MATCHLINE TO SHEET V-208

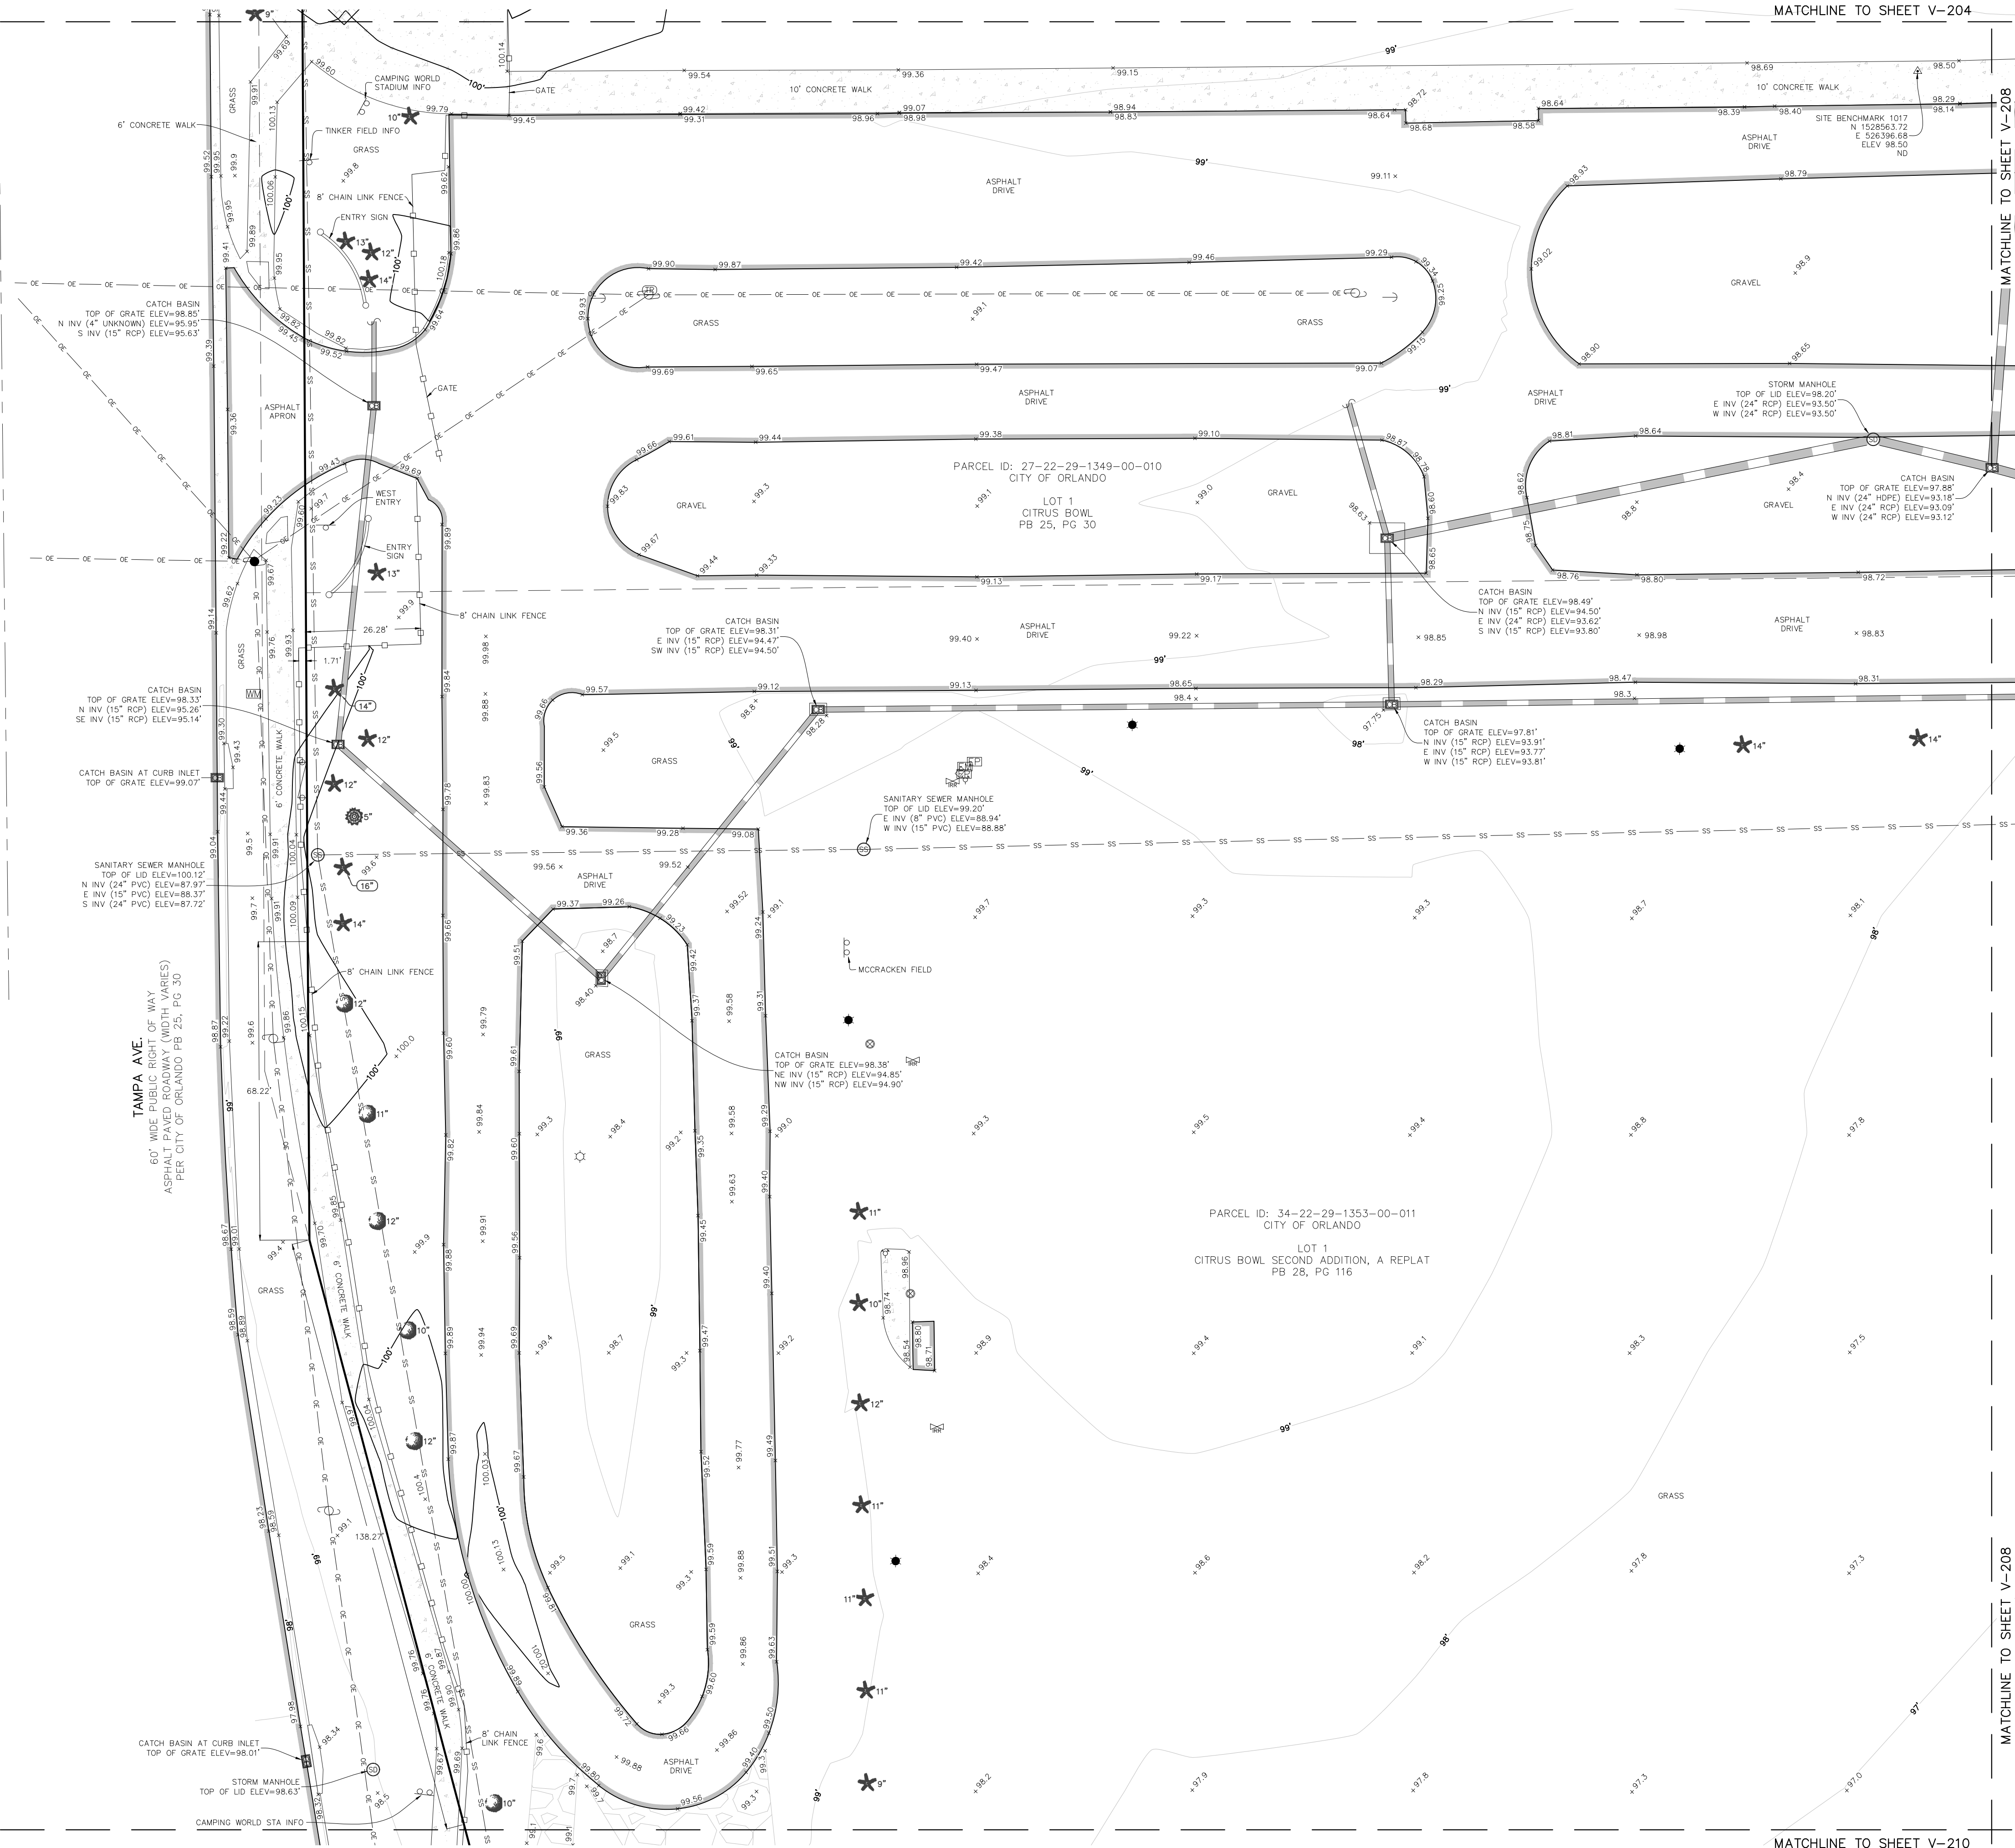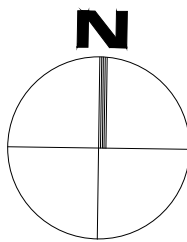


MATCHLINE TO SHEET V-210

MATCHLINE TO SHEET V-210

CAMPING WORLD STADIUM
DLR GROUP
TOPOGRAPHIC SURVEY

LOCATED IN
SECTIONS 27 & 34, TOWNSHIP 22 SOUTH, RANGE 29 EAST
CITY OF ORLANDO
ORANGE COUNTY, FLORIDA

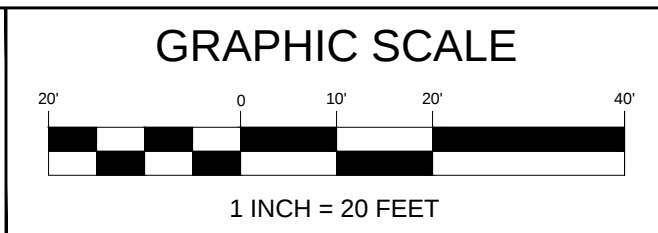


REVISIONS			
No.	DATE	BY	DESCRIPTION

PROJECT No.	1250009
SURVEY BY	MC
SURVEY DATE	2025 APRIL 24
DRAWN BY	BSAC
DRAWN DATE	2025 MAY 05
REVIEWED BY	SM
APPROVED BY	SM

DRAWING No.	V-207
SHEET	10 OF 15


L & S Diversified
PROFESSIONAL SURVEYOR & MAPPER BUSINESS LICENSE | L1871029

4776 NEW WOOD STREET | SUITE 100 | ORLANDO, FL 32834
PHONE 407.802.3535
WWW.LSURVEYOR.COM | INFO@LSURVEYOR.COM

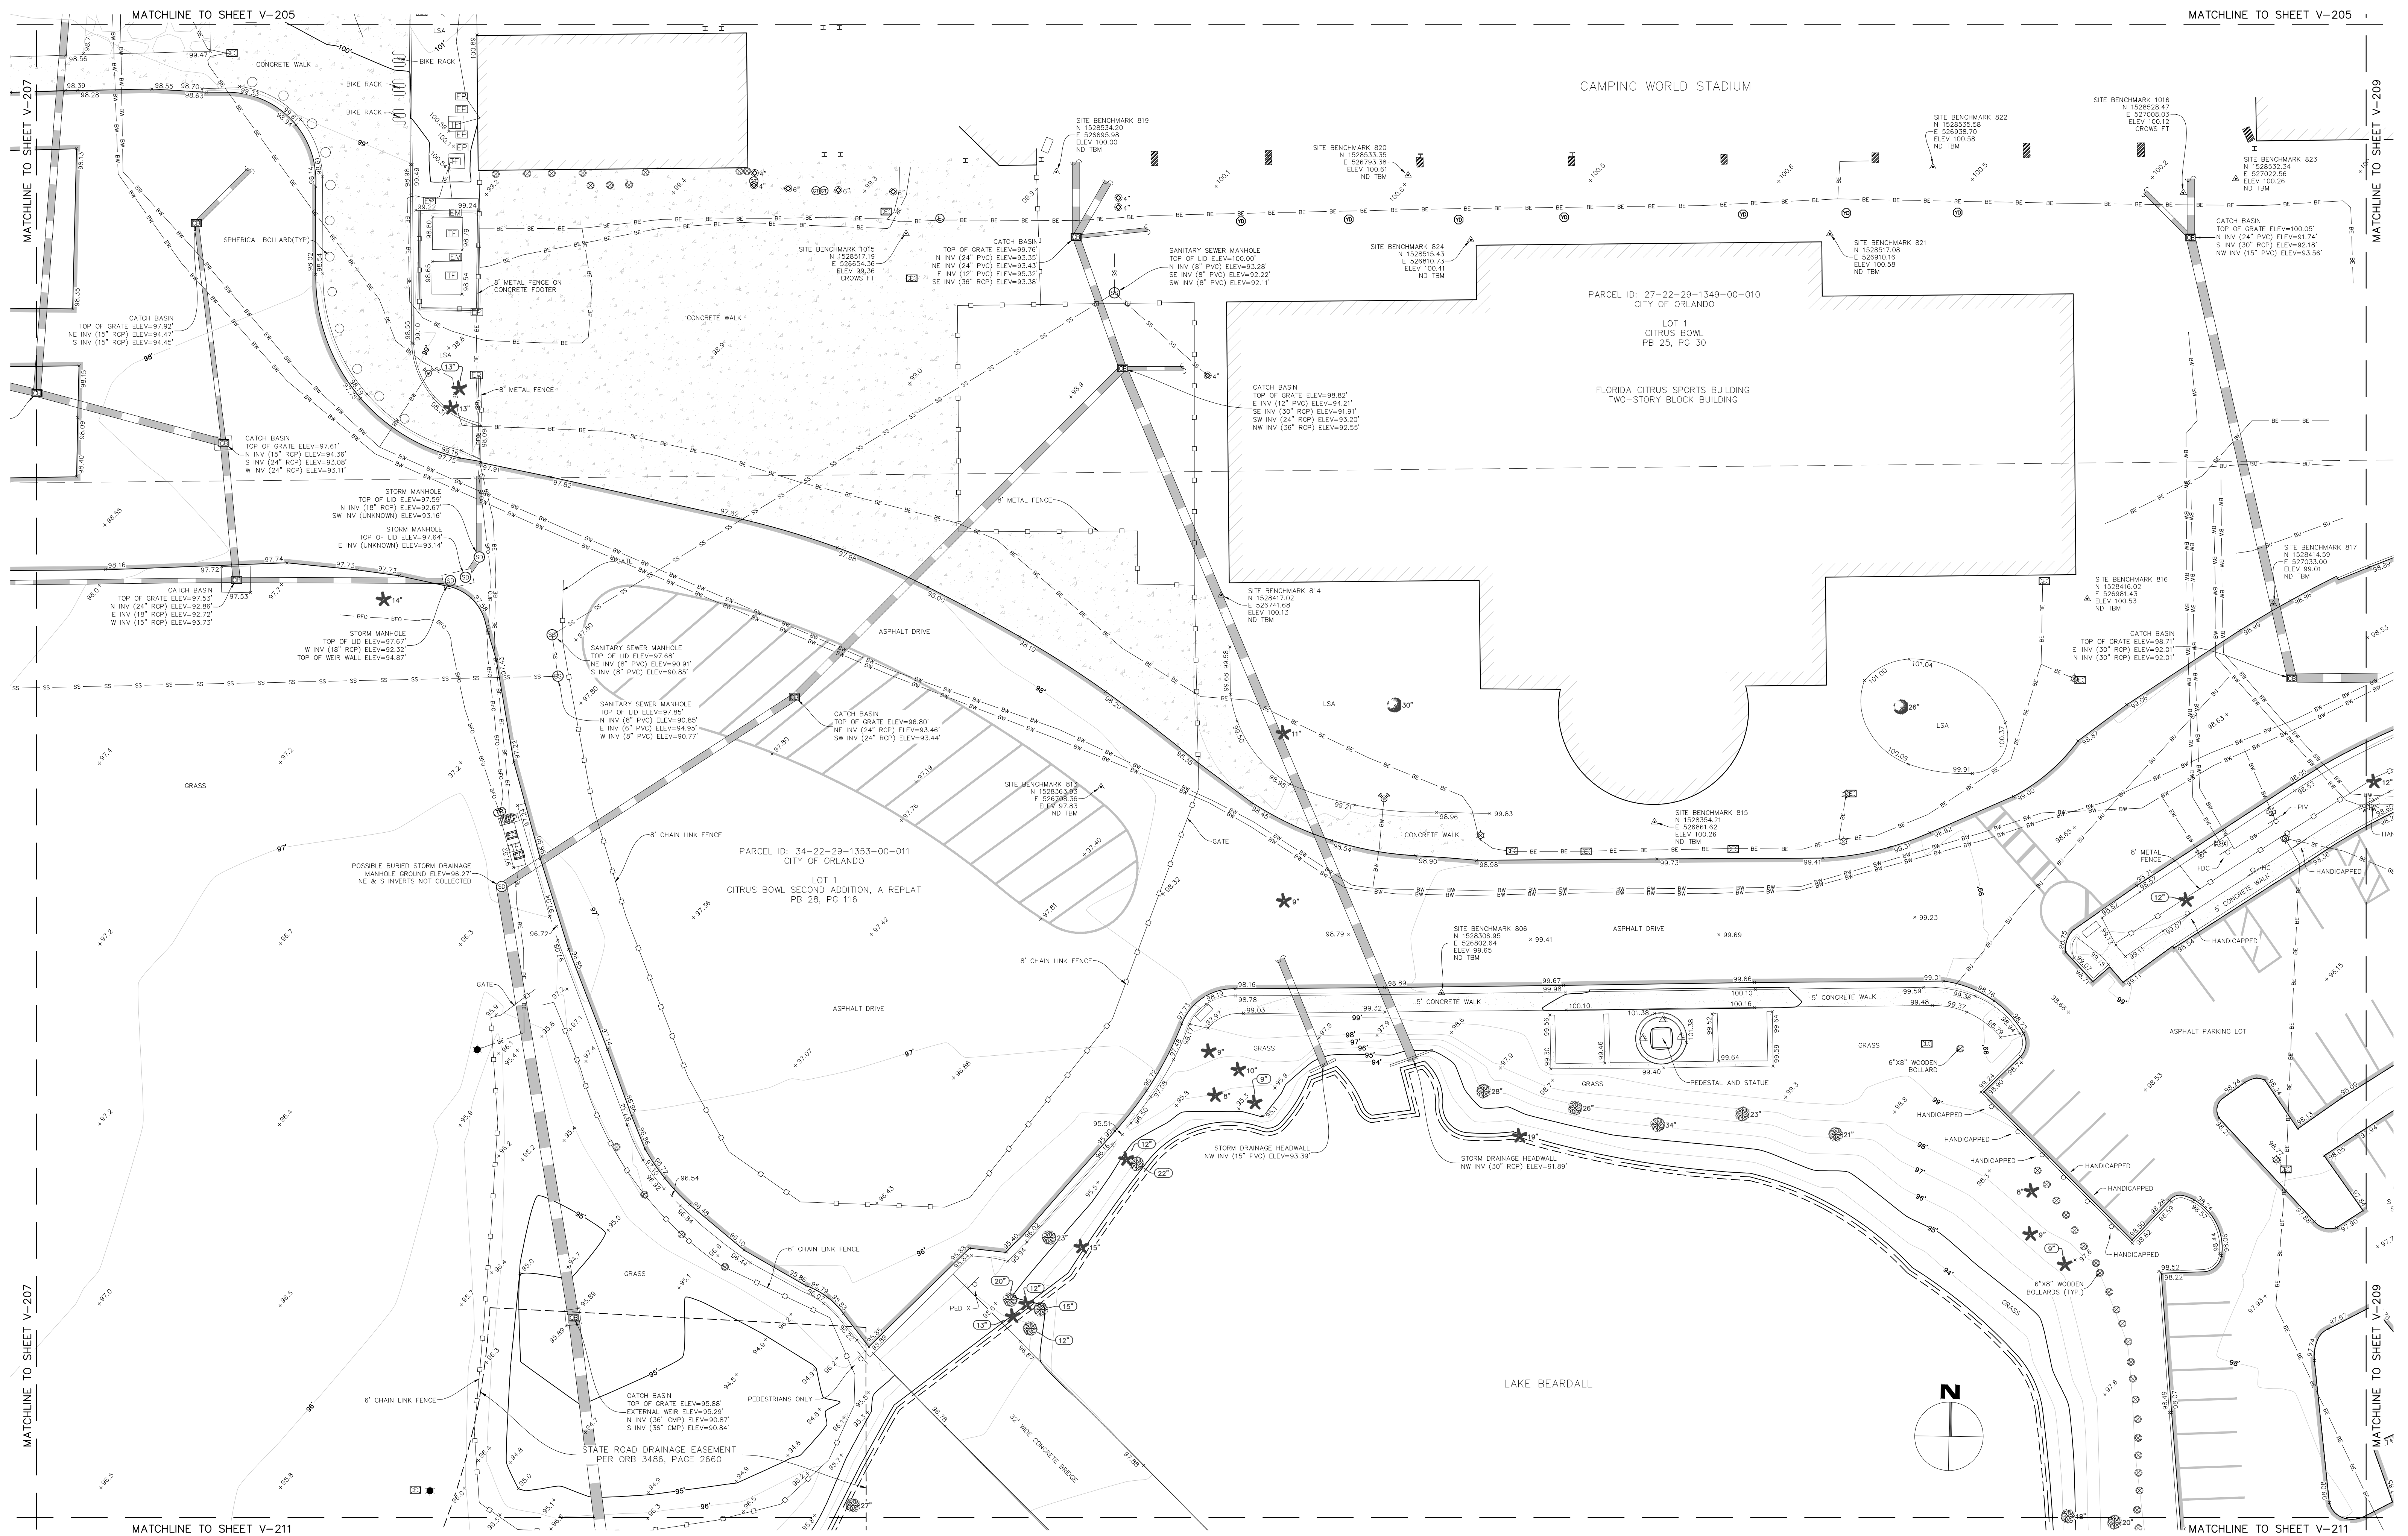

CAMPING WORLD STADIUM
DLR GROUP
TOPOGRAPHIC SURVEY



LOCATED IN
SECTIONS 27 & 34, TOWNSHIP 22 SOUTH, RANGE 29 EAST
CITY OF ORLANDO
ORANGE COUNTY, FLORIDA

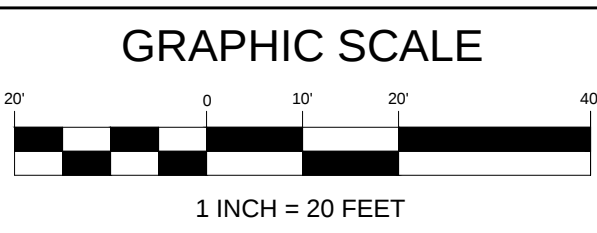[illegible]

PROJECT No.	1250009
SURVEY BY	MC
SURVEY DATE	2025.APRIL.24
DRAWN BY	B5/LC
DRAWN DATE	2025.MAY.06
REVIEWED BY	SM
APPROVED BY	SM


DRAWING No.
V-208
SHEET
11 OF 15



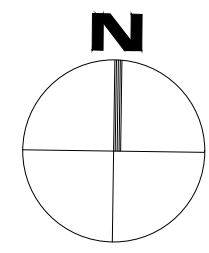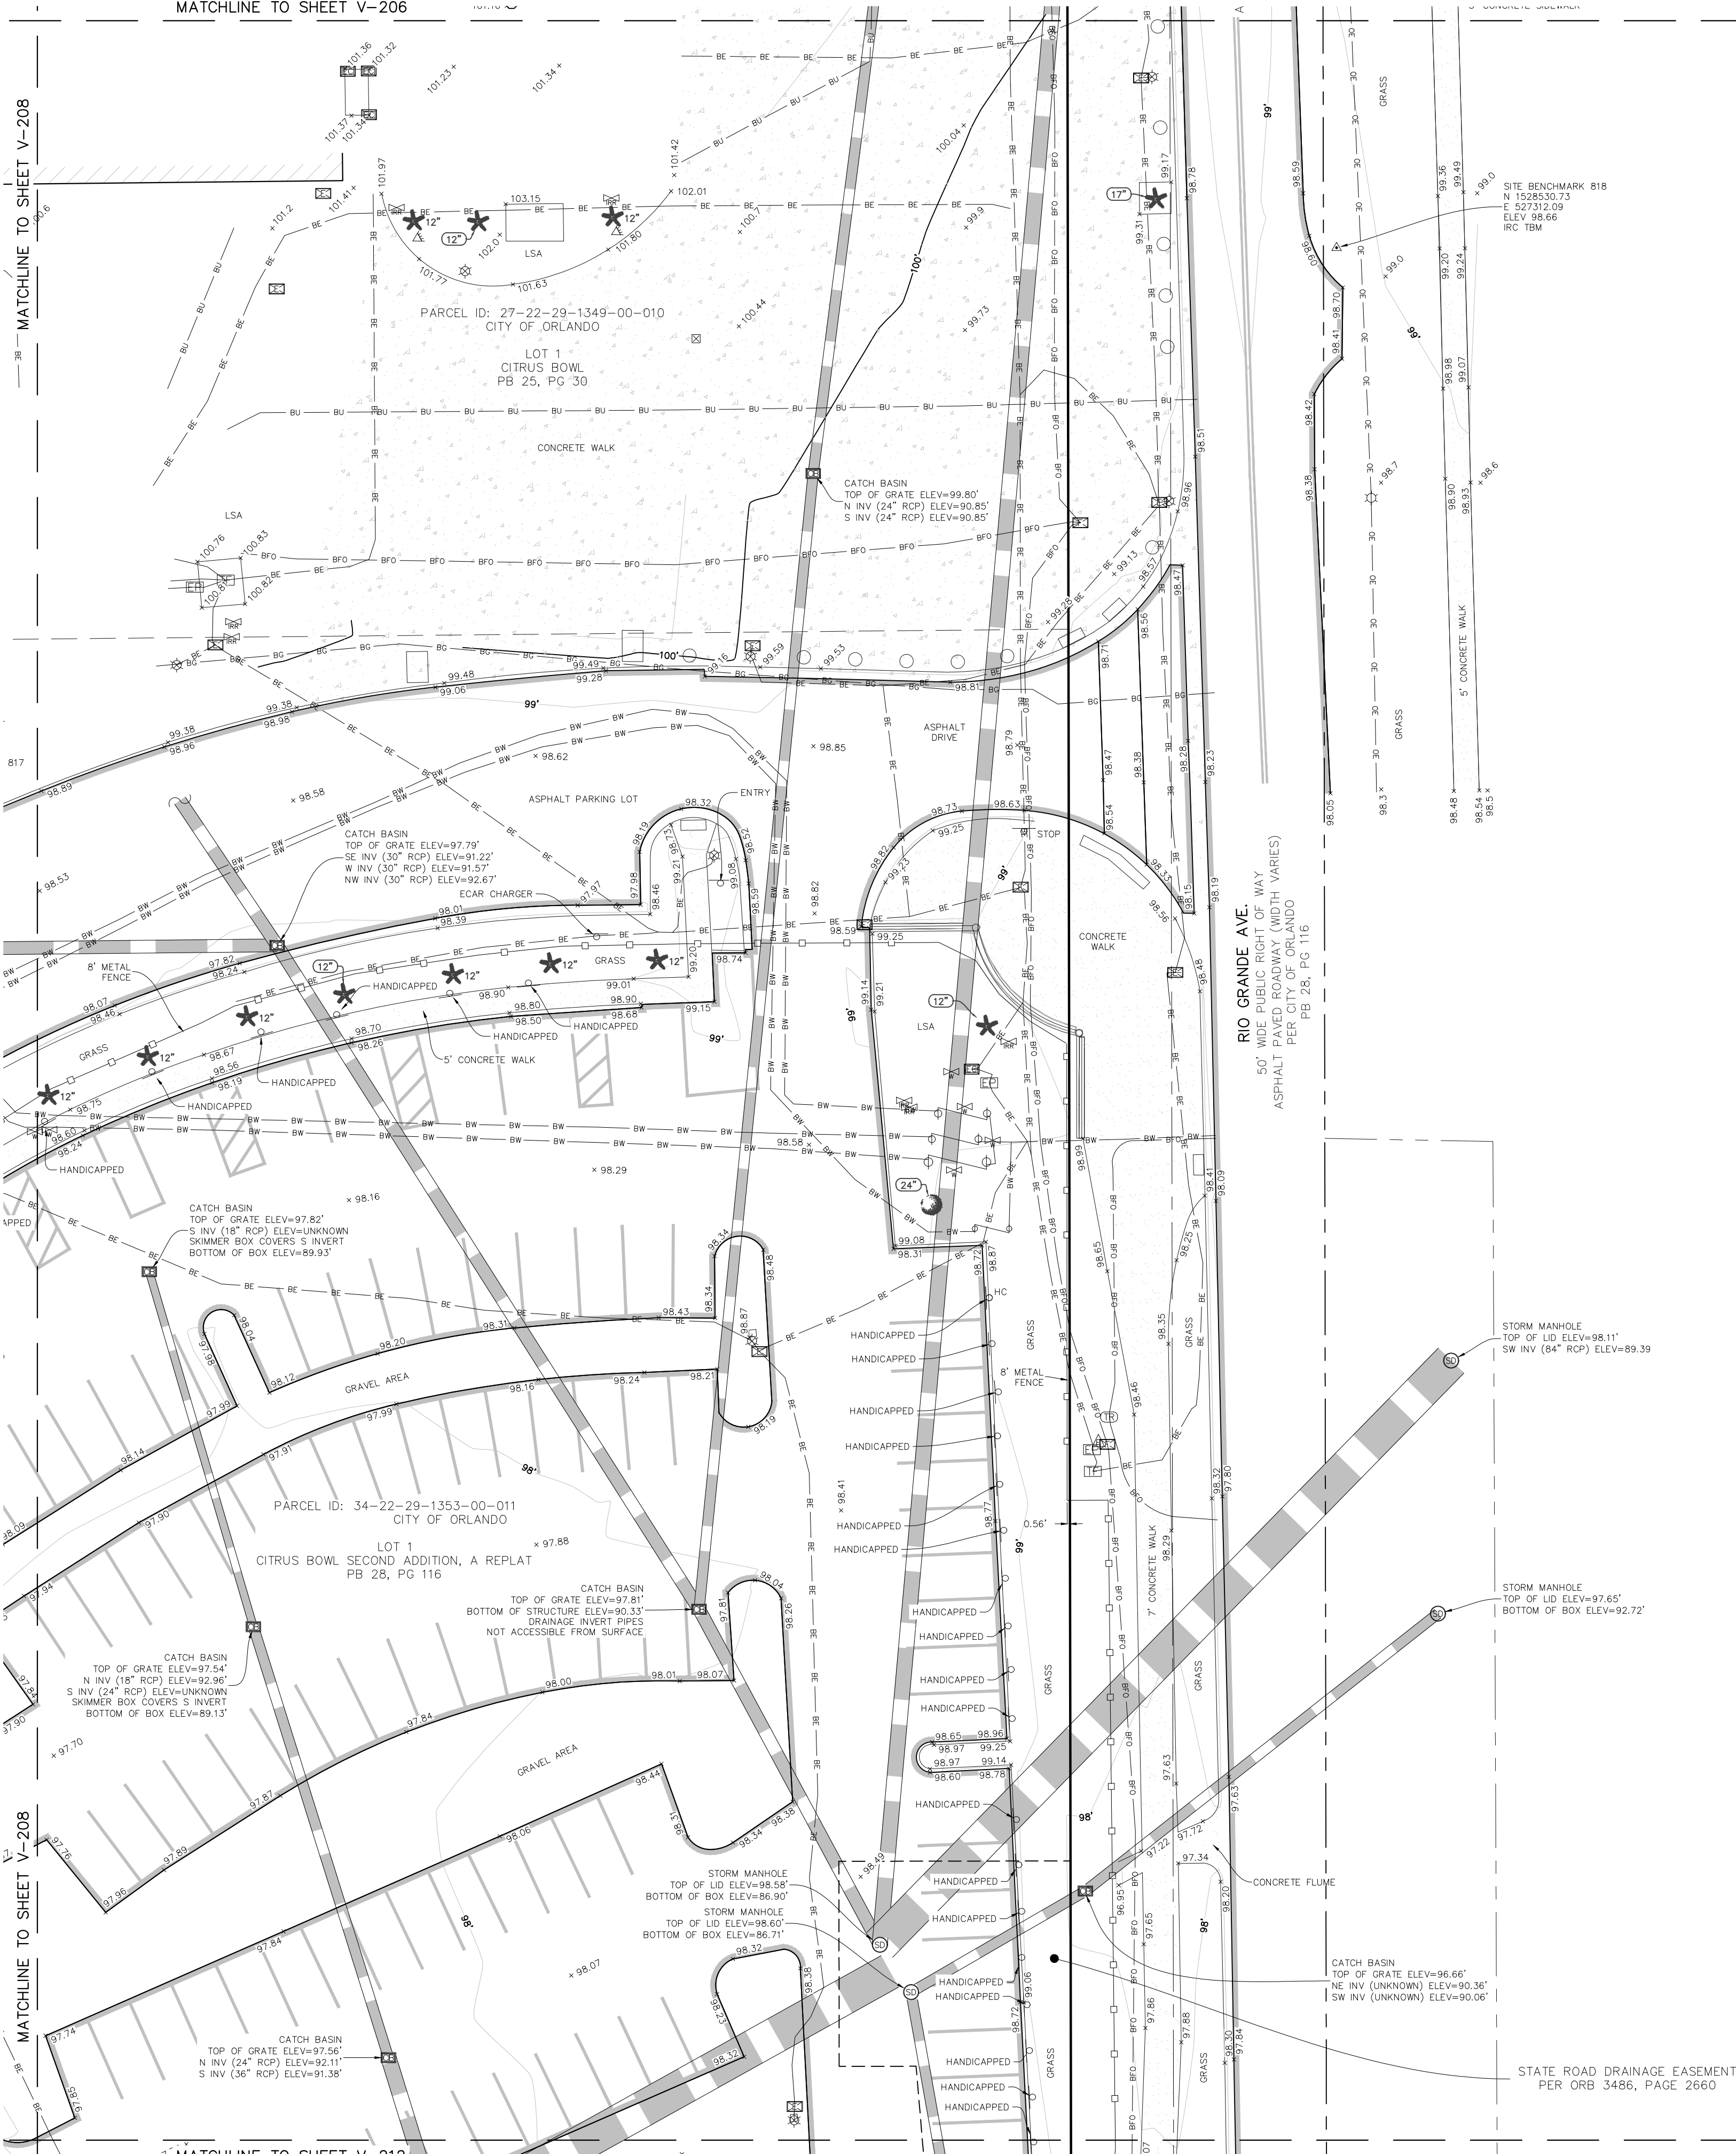

CAMPING WORLD STADIUM
DLR GROUP
TOPOGRAPHIC SURVEY

LOCATED IN
SECTIONS 27 & 34, TOWNSHIP 22 SOUTH, RANGE 29 EAST
CITY OF ORLANDO
ORANGE COUNTY, FLORIDA


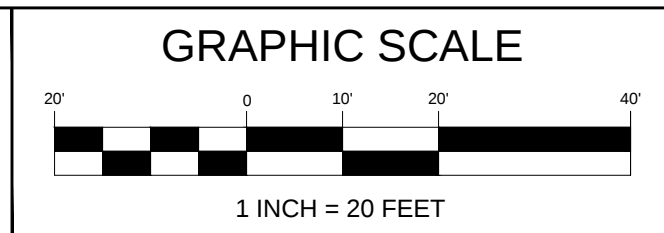


REVISIONS			
No.	DATE	BY	DESCRIPTION

PROJECT No.	1250009
SURVEY BY	MC
SURVEY DATE	2025 APRIL 24
DRAWN BY	BSAC
DRAWN DATE	2025 MAY 06
DESIGNED BY	SM
APPROVED BY	SM


DRAWING No.
V-209
SHEET
12 OF 15

L & S Diversified
4700 NEW WOOD STREET | SUITE 100 | ORLANDO, FL 32834
PHONE 407.881.3535
WWW.LSURVEYOR.COM | INFO@LSURVEYOR.COM
PROFESSIONAL SURVEYOR & MAPPER BUSINESS LICENSE | LB17829

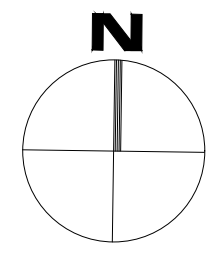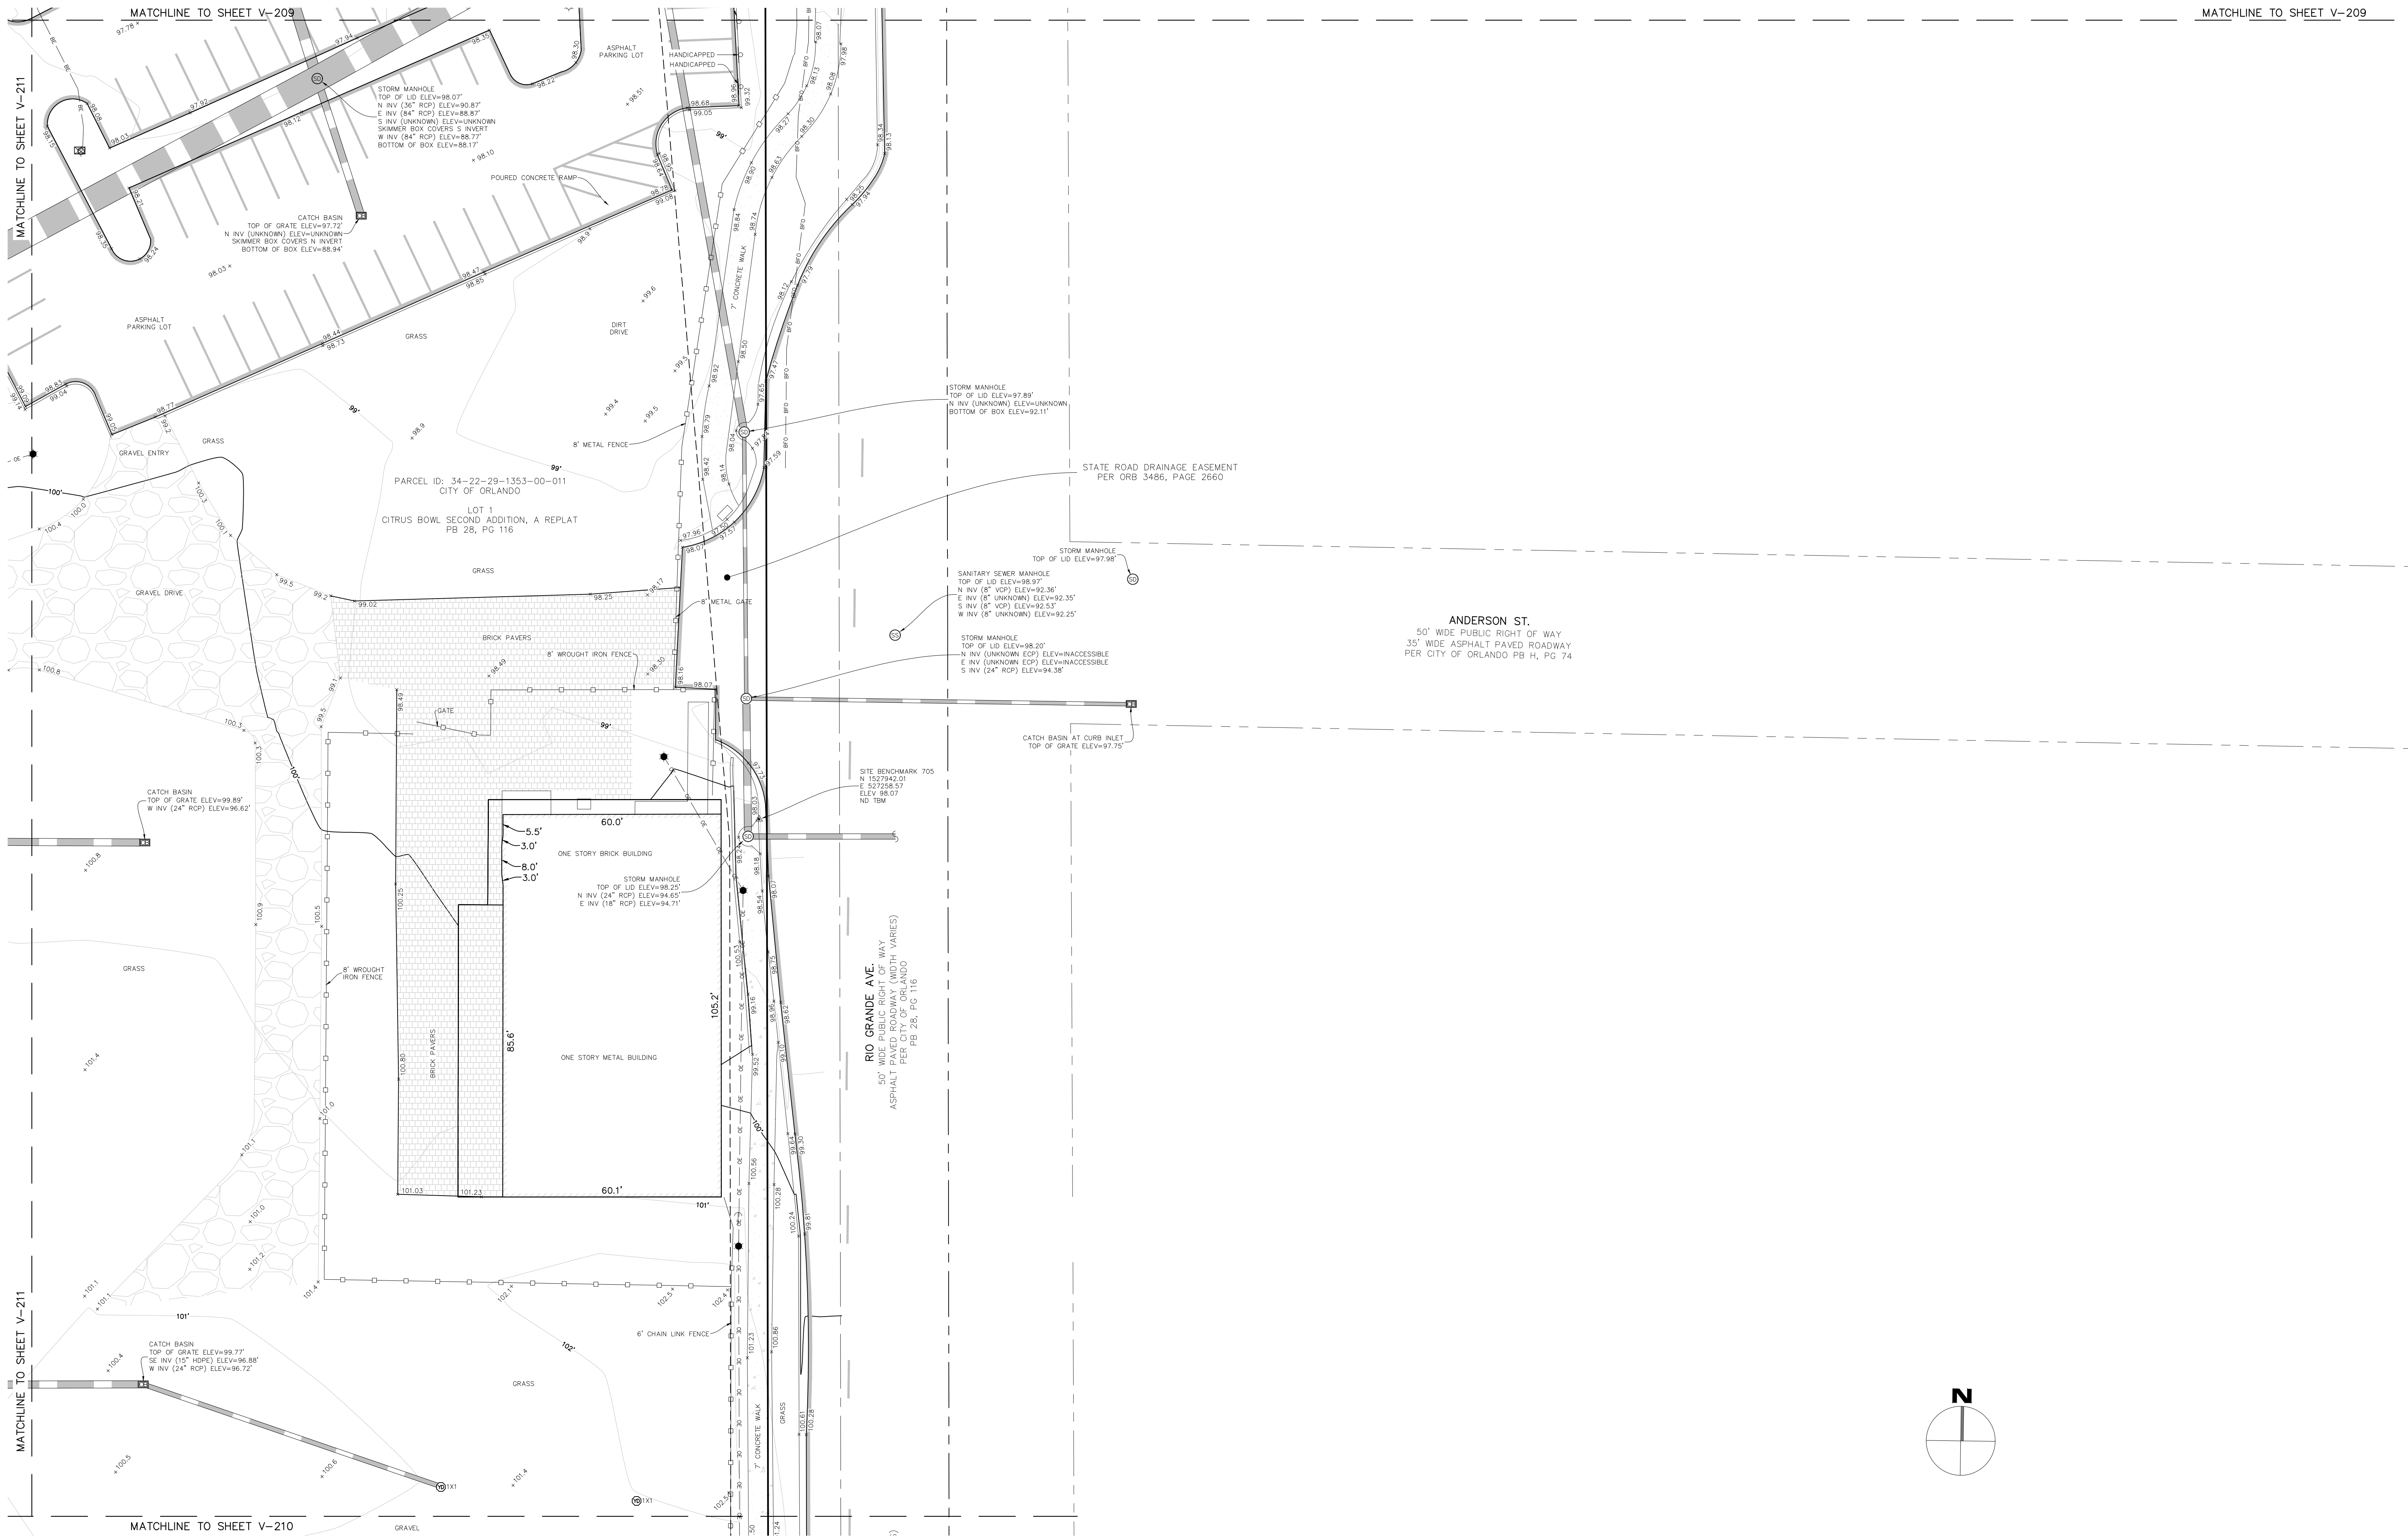

CAMPING WORLD STADIUM
DLR GROUP
TOPOGRAPHIC SURVEY

LOCATED IN
SECTIONS 27 & 34, TOWNSHIP 22 SOUTH, RANGE 29 EAST
CITY OF ORLANDO
ORANGE COUNTY, FLORIDA

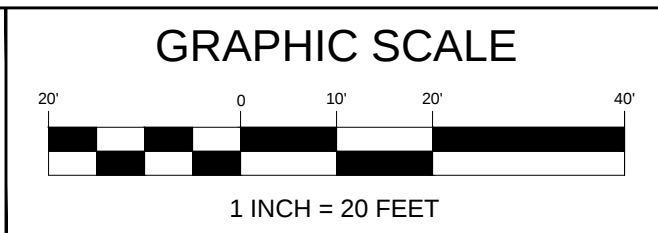


REVISIONS			
No.	DATE	BY	DESCRIPTION

PROJECT No. 1250009
SURVEY BY MC
SURVEY DATE 2025 APRIL 24
DRAWN BY BSAC
DRAWN DATE 2025 MAY 06
REVIEWED BY SM
APPROVED BY SM

DRAWING No. V-212
SHEET 15 OF 15


**L & S
Diversified**

7770 NEW BRIDGE STREET | SUITE 100 | ORLANDO, FL 32834
PHONE 407.801.3535
WWW.LSURVEYOR.COM | INFO@LSURVEYOR.COM
PROFESSIONAL SURVEYOR & MAPPER BUSINESS LICENSE | LB17023

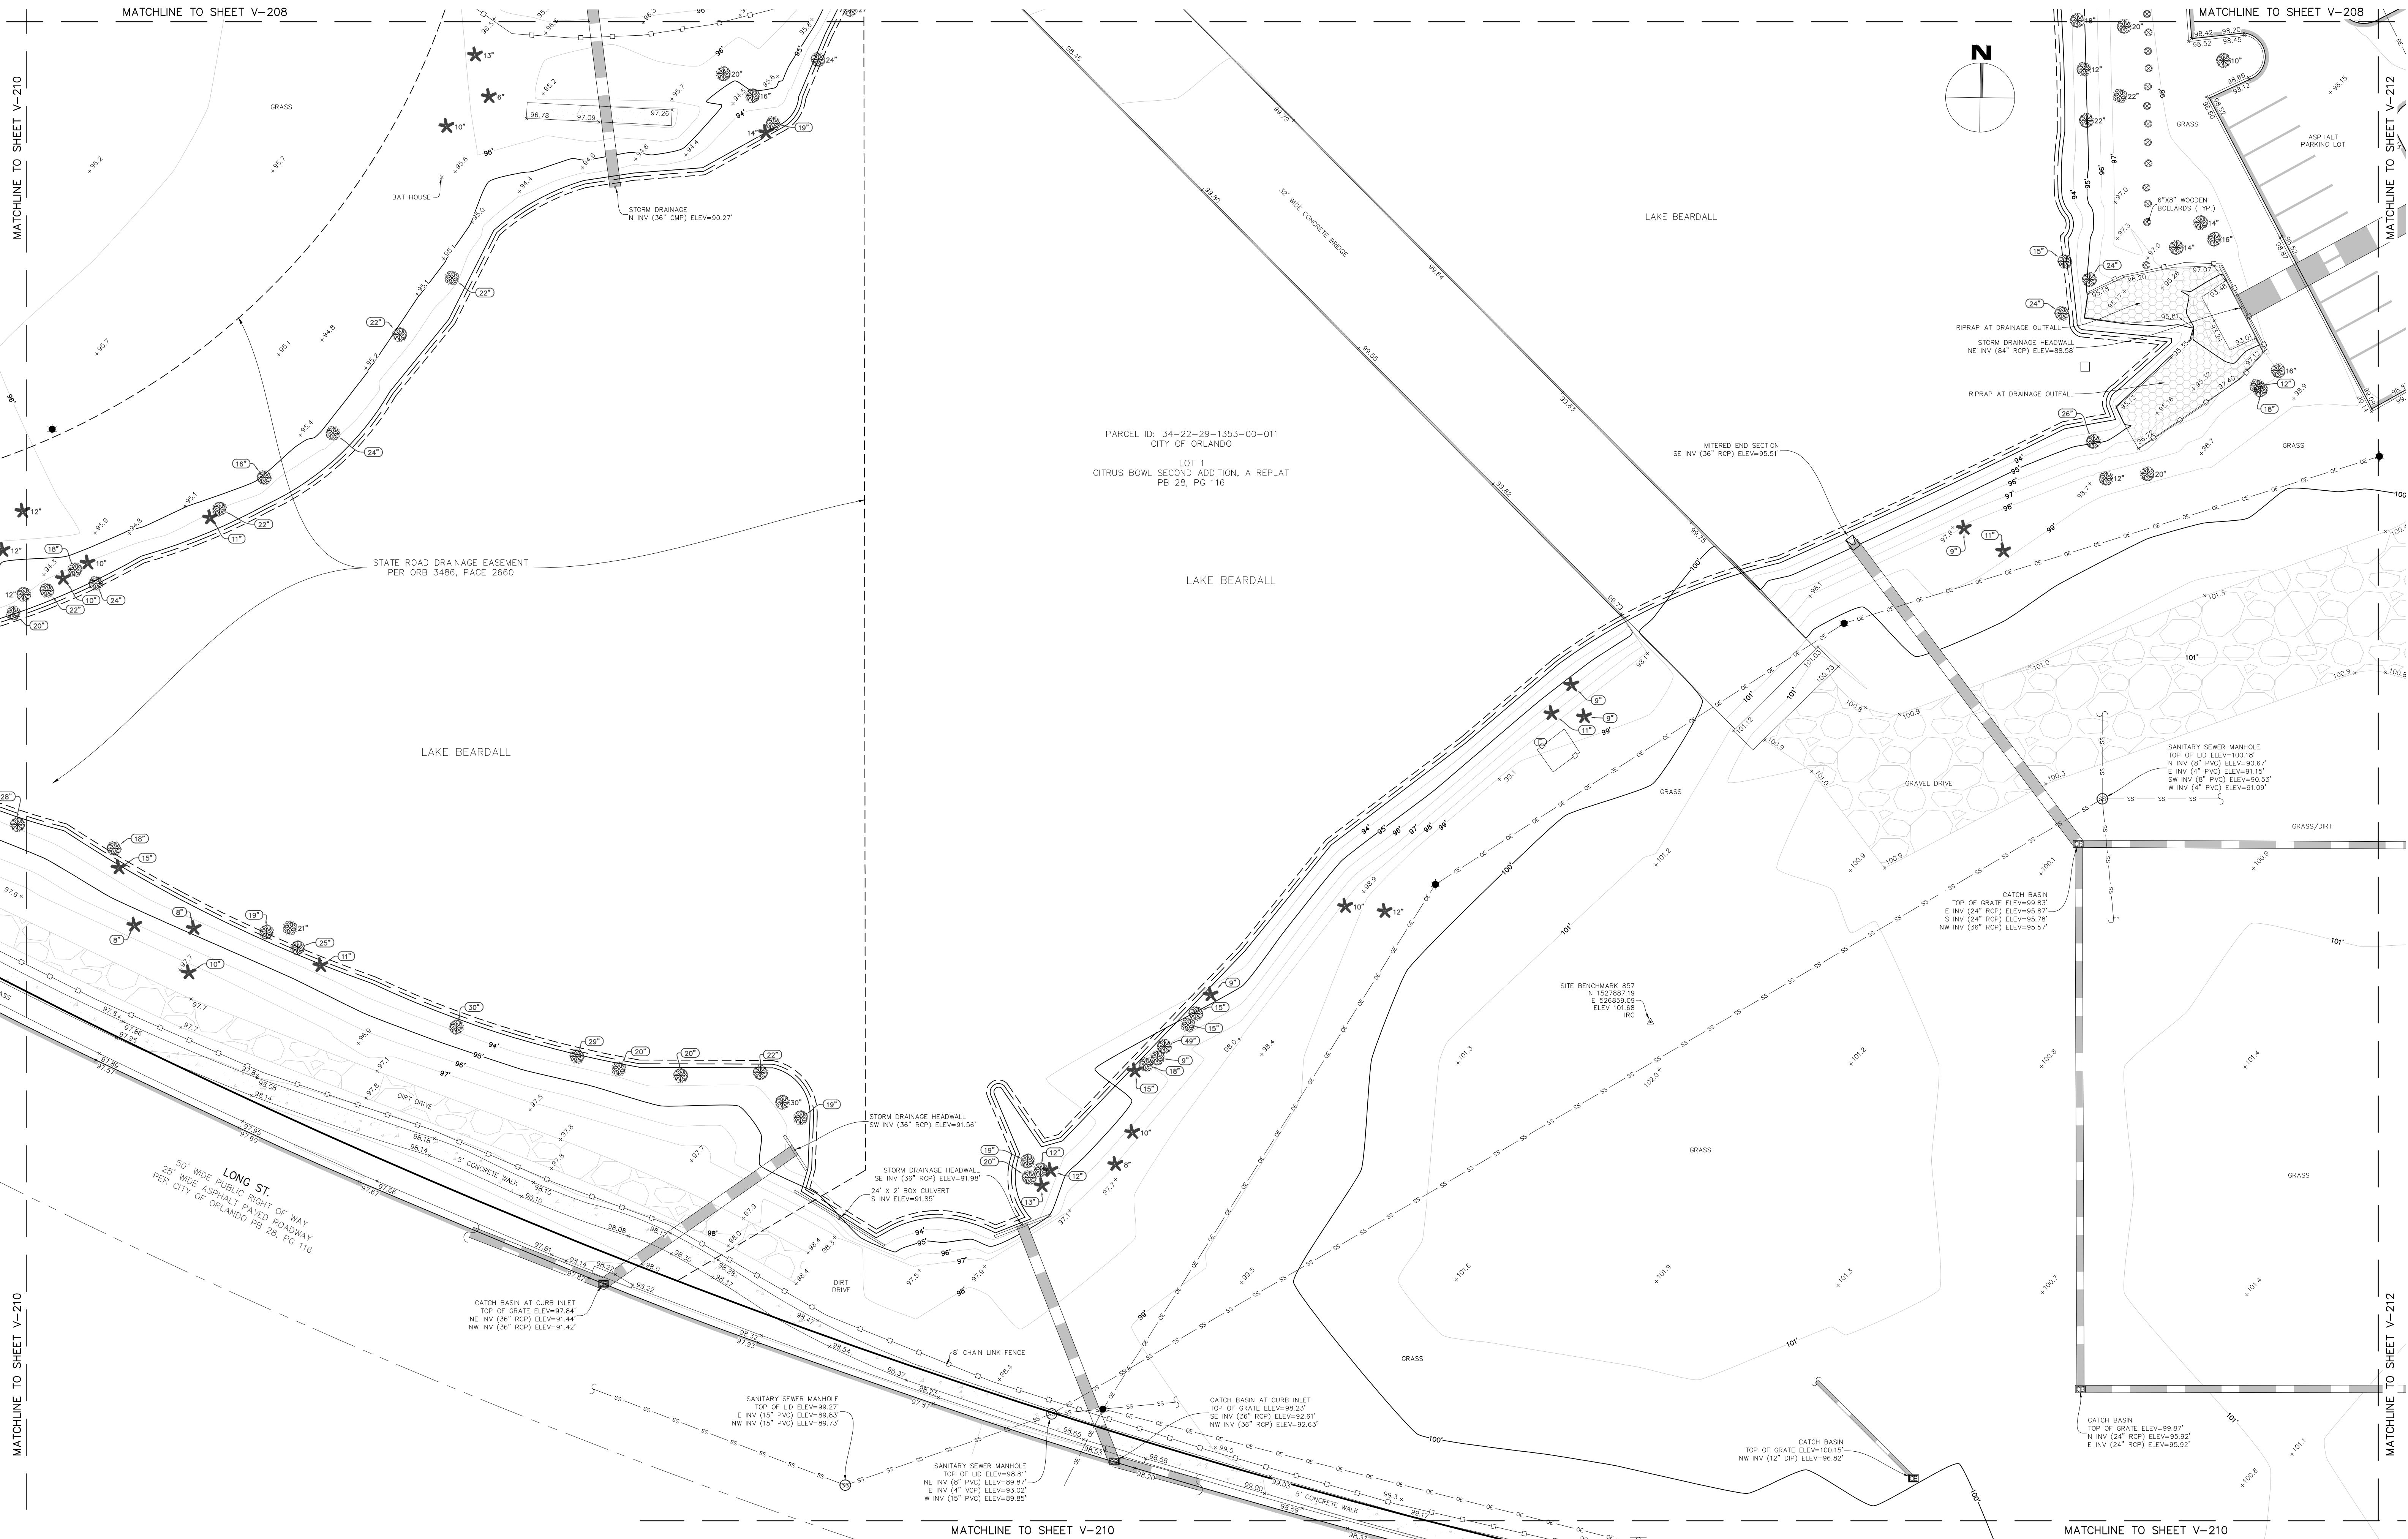

CAMPING WORLD STADIUM
DLR GROUP
TOPOGRAPHIC SURVEY

LOCATED IN
SECTIONS 27 & 34, TOWNSHIP 22 SOUTH, RANGE 29 EAST
CITY OF ORLANDO
ORANGE COUNTY, FLORIDA


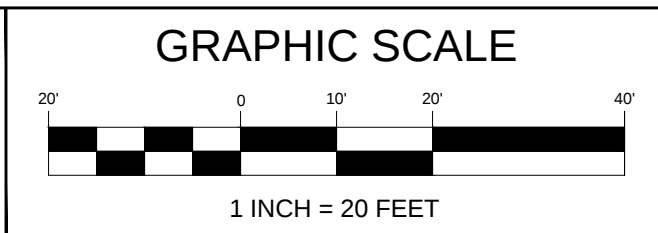


REVISIONS			
No.	DATE	BY	DESCRIPTION

PROJECT No. 1250009
SURVEY BY MC
SURVEY DATE 2025 APRIL 24
DRAWN BY BSAC
DRAWN DATE 2025 MAY 06
REVIEWED BY SM
APPROVED BY SM

DRAWING No. V-211
SHEET 14 OF 15


L & S Diversified
4700 NEW WOOD STREET | SUITE 100 | ORLANDO, FL 32834
PHONE 407.802.3036
WWW.LSURVEYOR.COM | INFO@LSURVEYOR.COM
PROFESSIONAL SURVEYOR & MAPPER BUSINESS LICENSE | 18178203

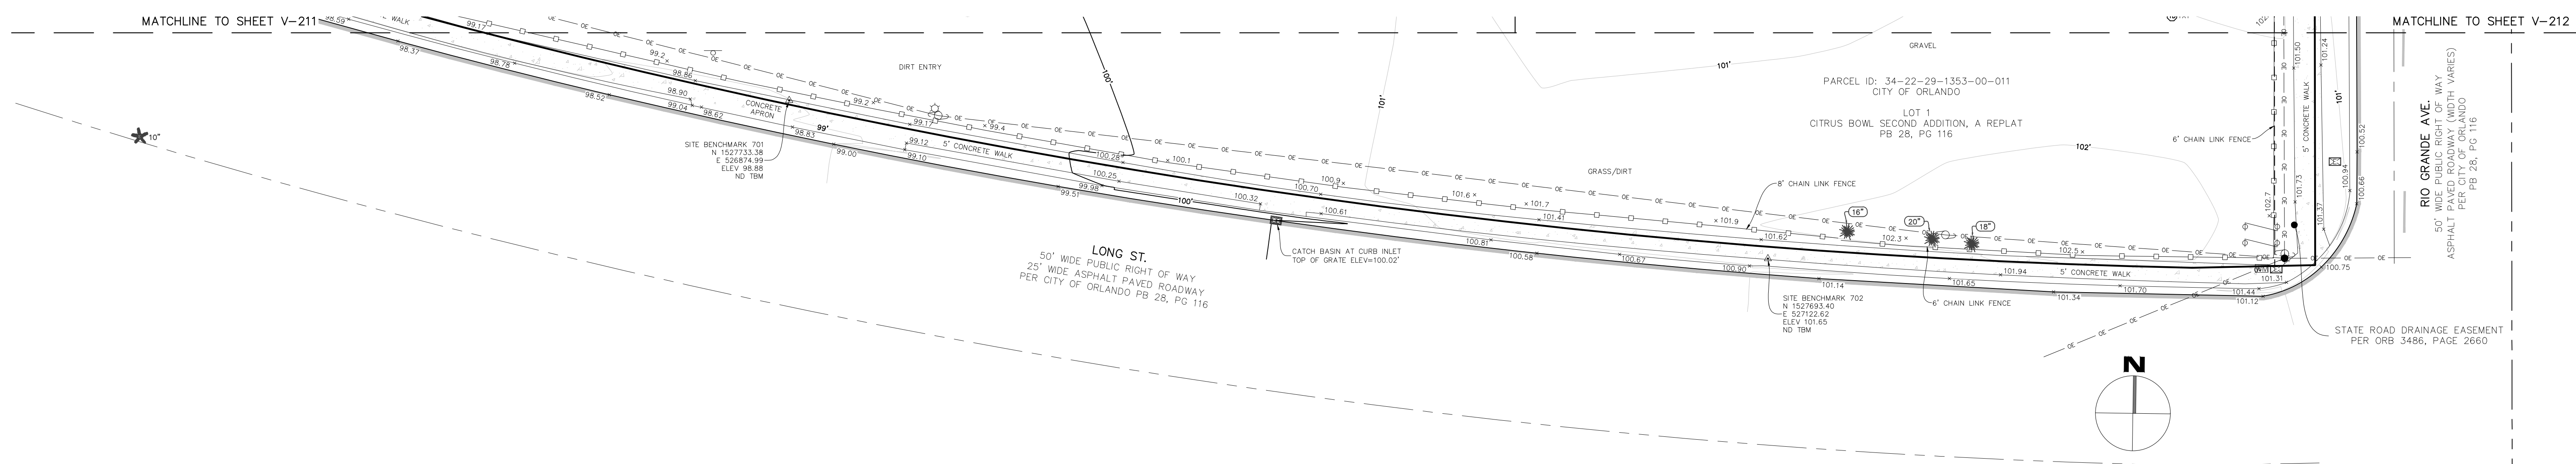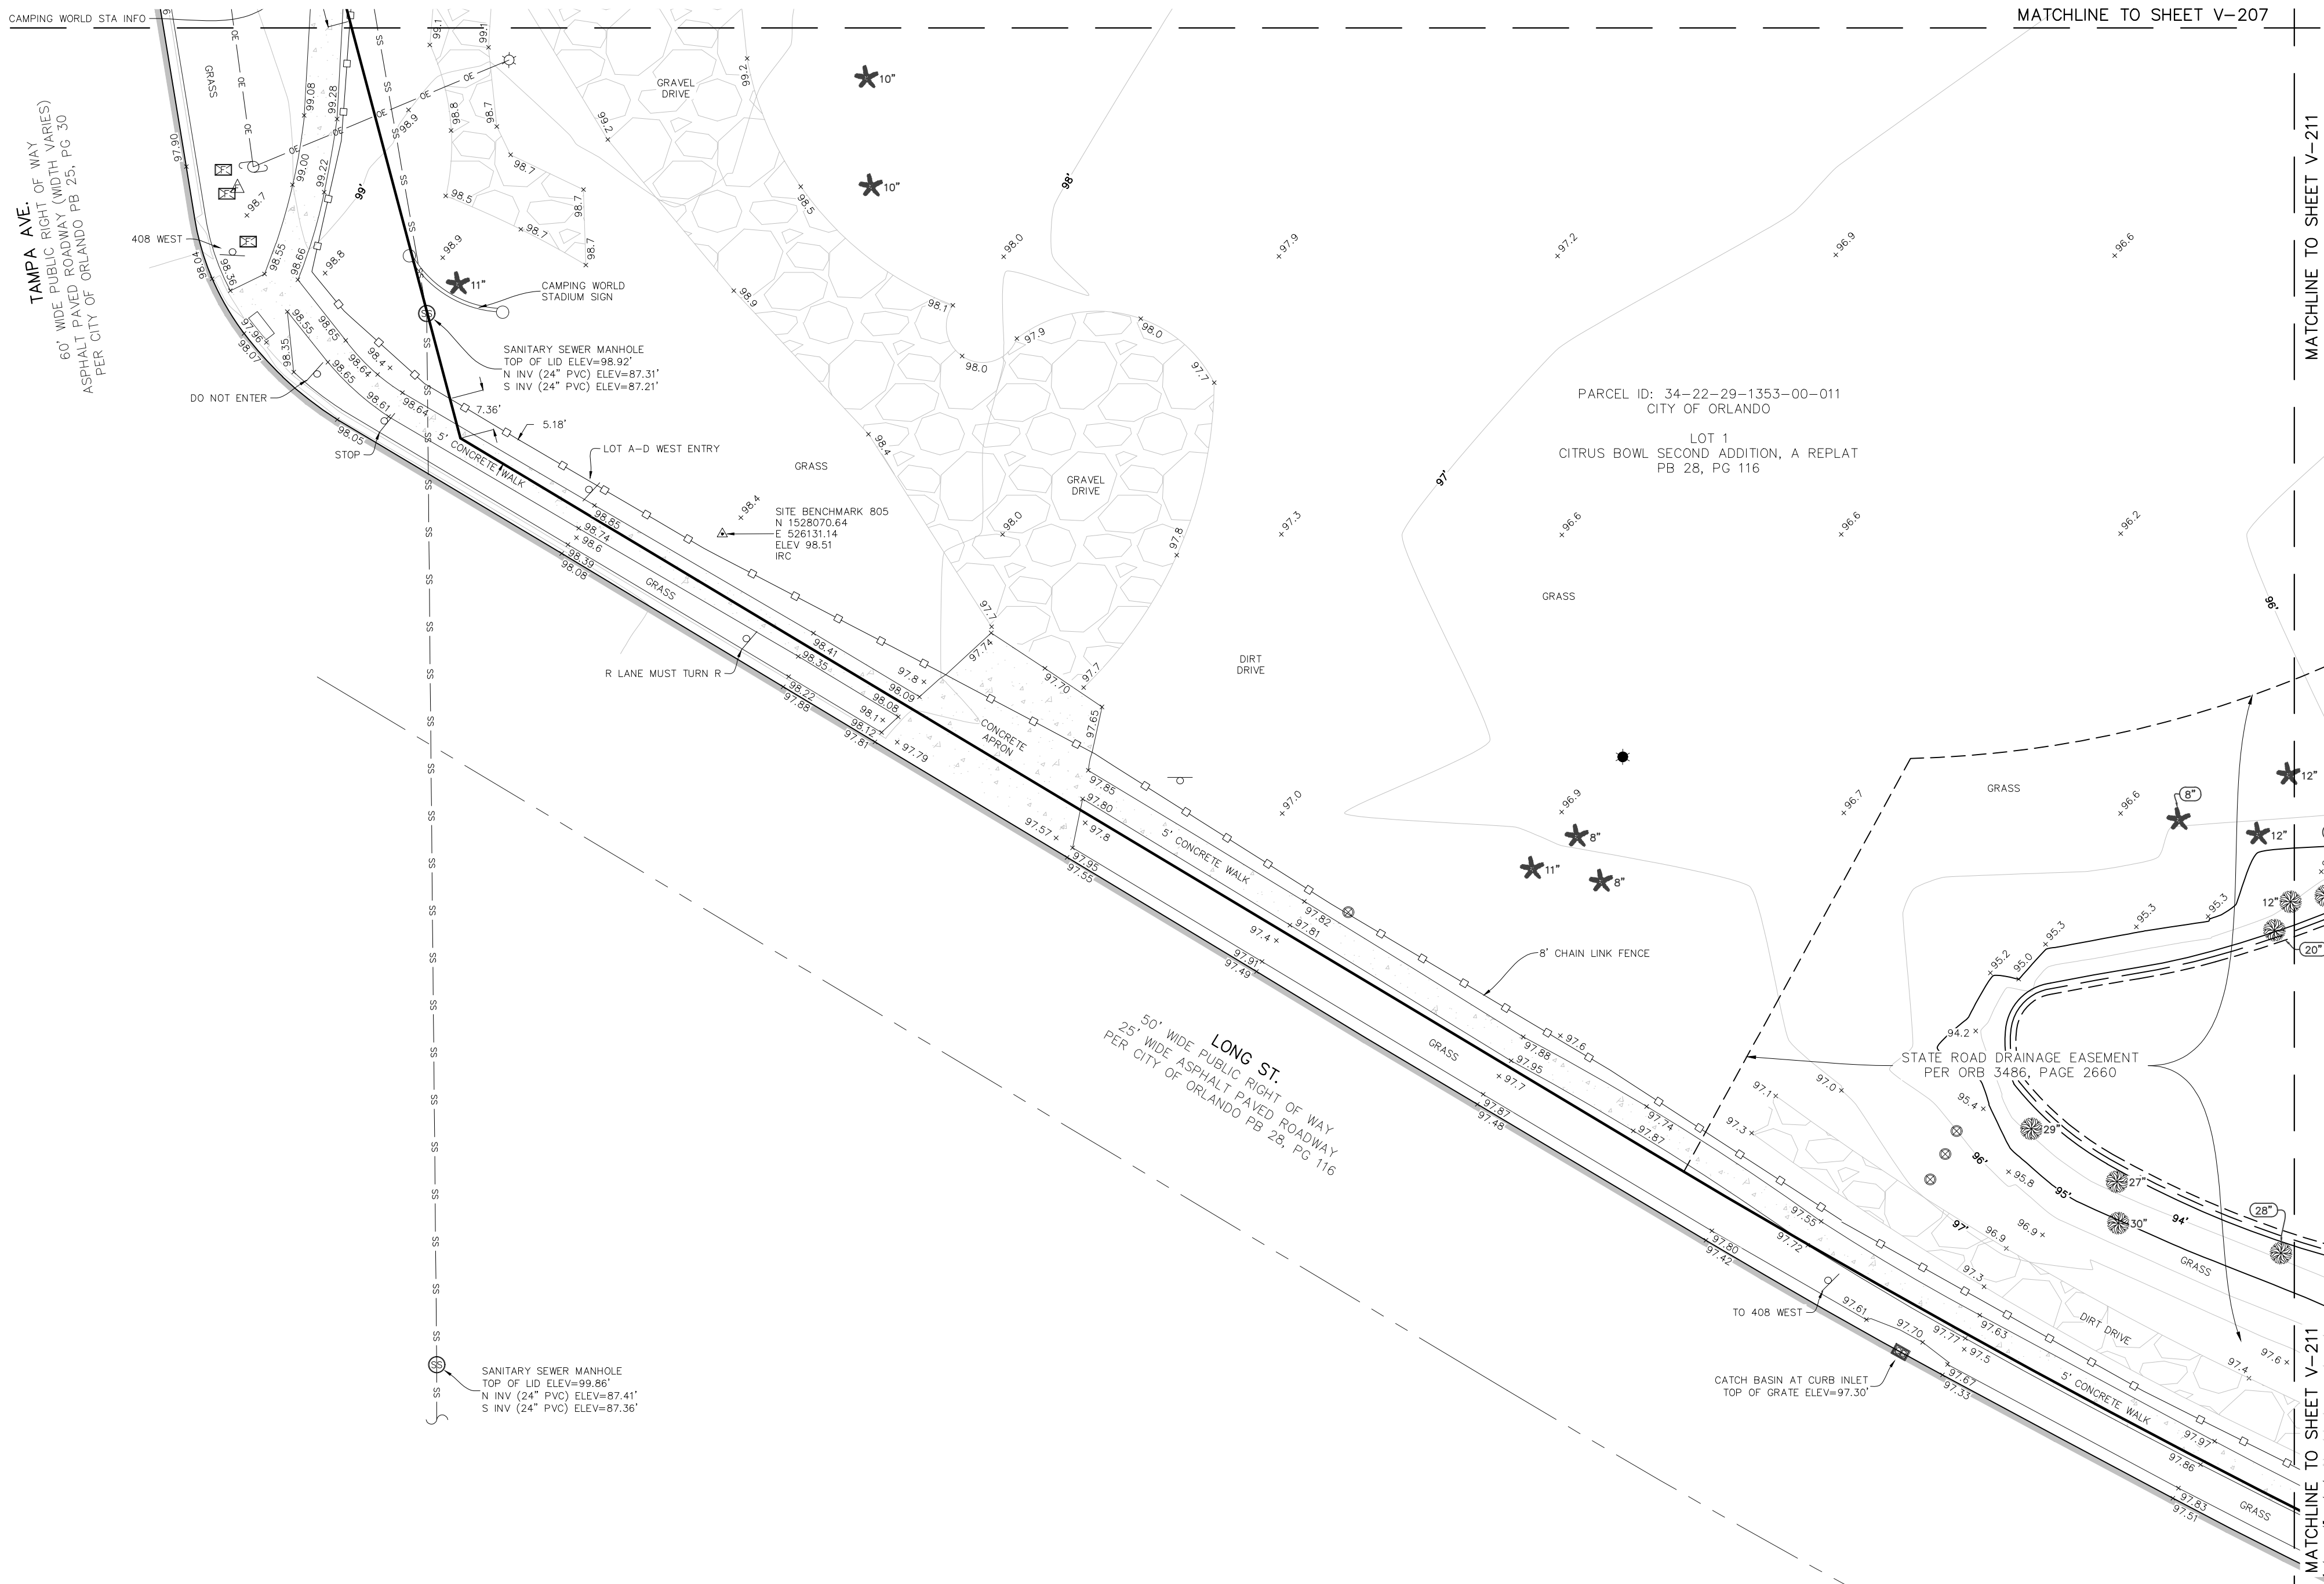

CAMPING WORLD STADIUM
DLR GROUP
TOPOGRAPHIC SURVEY

LOCATED IN

SECTIONS 27 & 34, TOWNSHIP 22 SOUTH, RANGE 29 EAST
CITY OF ORLANDO
ORANGE COUNTY, FLORIDA

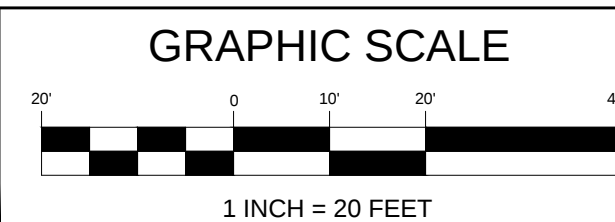[illegible]

PROJECT No.	1250009
SURVEY BY	MC
SURVEY DATE	2025.APRIL.24
DRAWN BY	BSAC
DRAWN DATE	2025.MAY.06
REVIEWED BY	SM
APPROVED BY	SM

DRAWING No.
V-210
SHEET
13 OF 15



L & S
Diversified
Professional Surveyors and Mappers
4778 NEW BROAD STREET | SUITE 100 | ORLANDO, FL 32814
PHONE 407.681.3636
WWW.LSSURVEYOR.COM | INFO@LSSURVEYOR.COM
PROFESSIONAL SURVEYOR & MAPPER BUSINESS LICENSE | LB#7825